


CAD User: PMH2 Date: 7-30-1998  
 DGN=ERUI6293.DGN  
 RASTER=ERUI6293.TIF

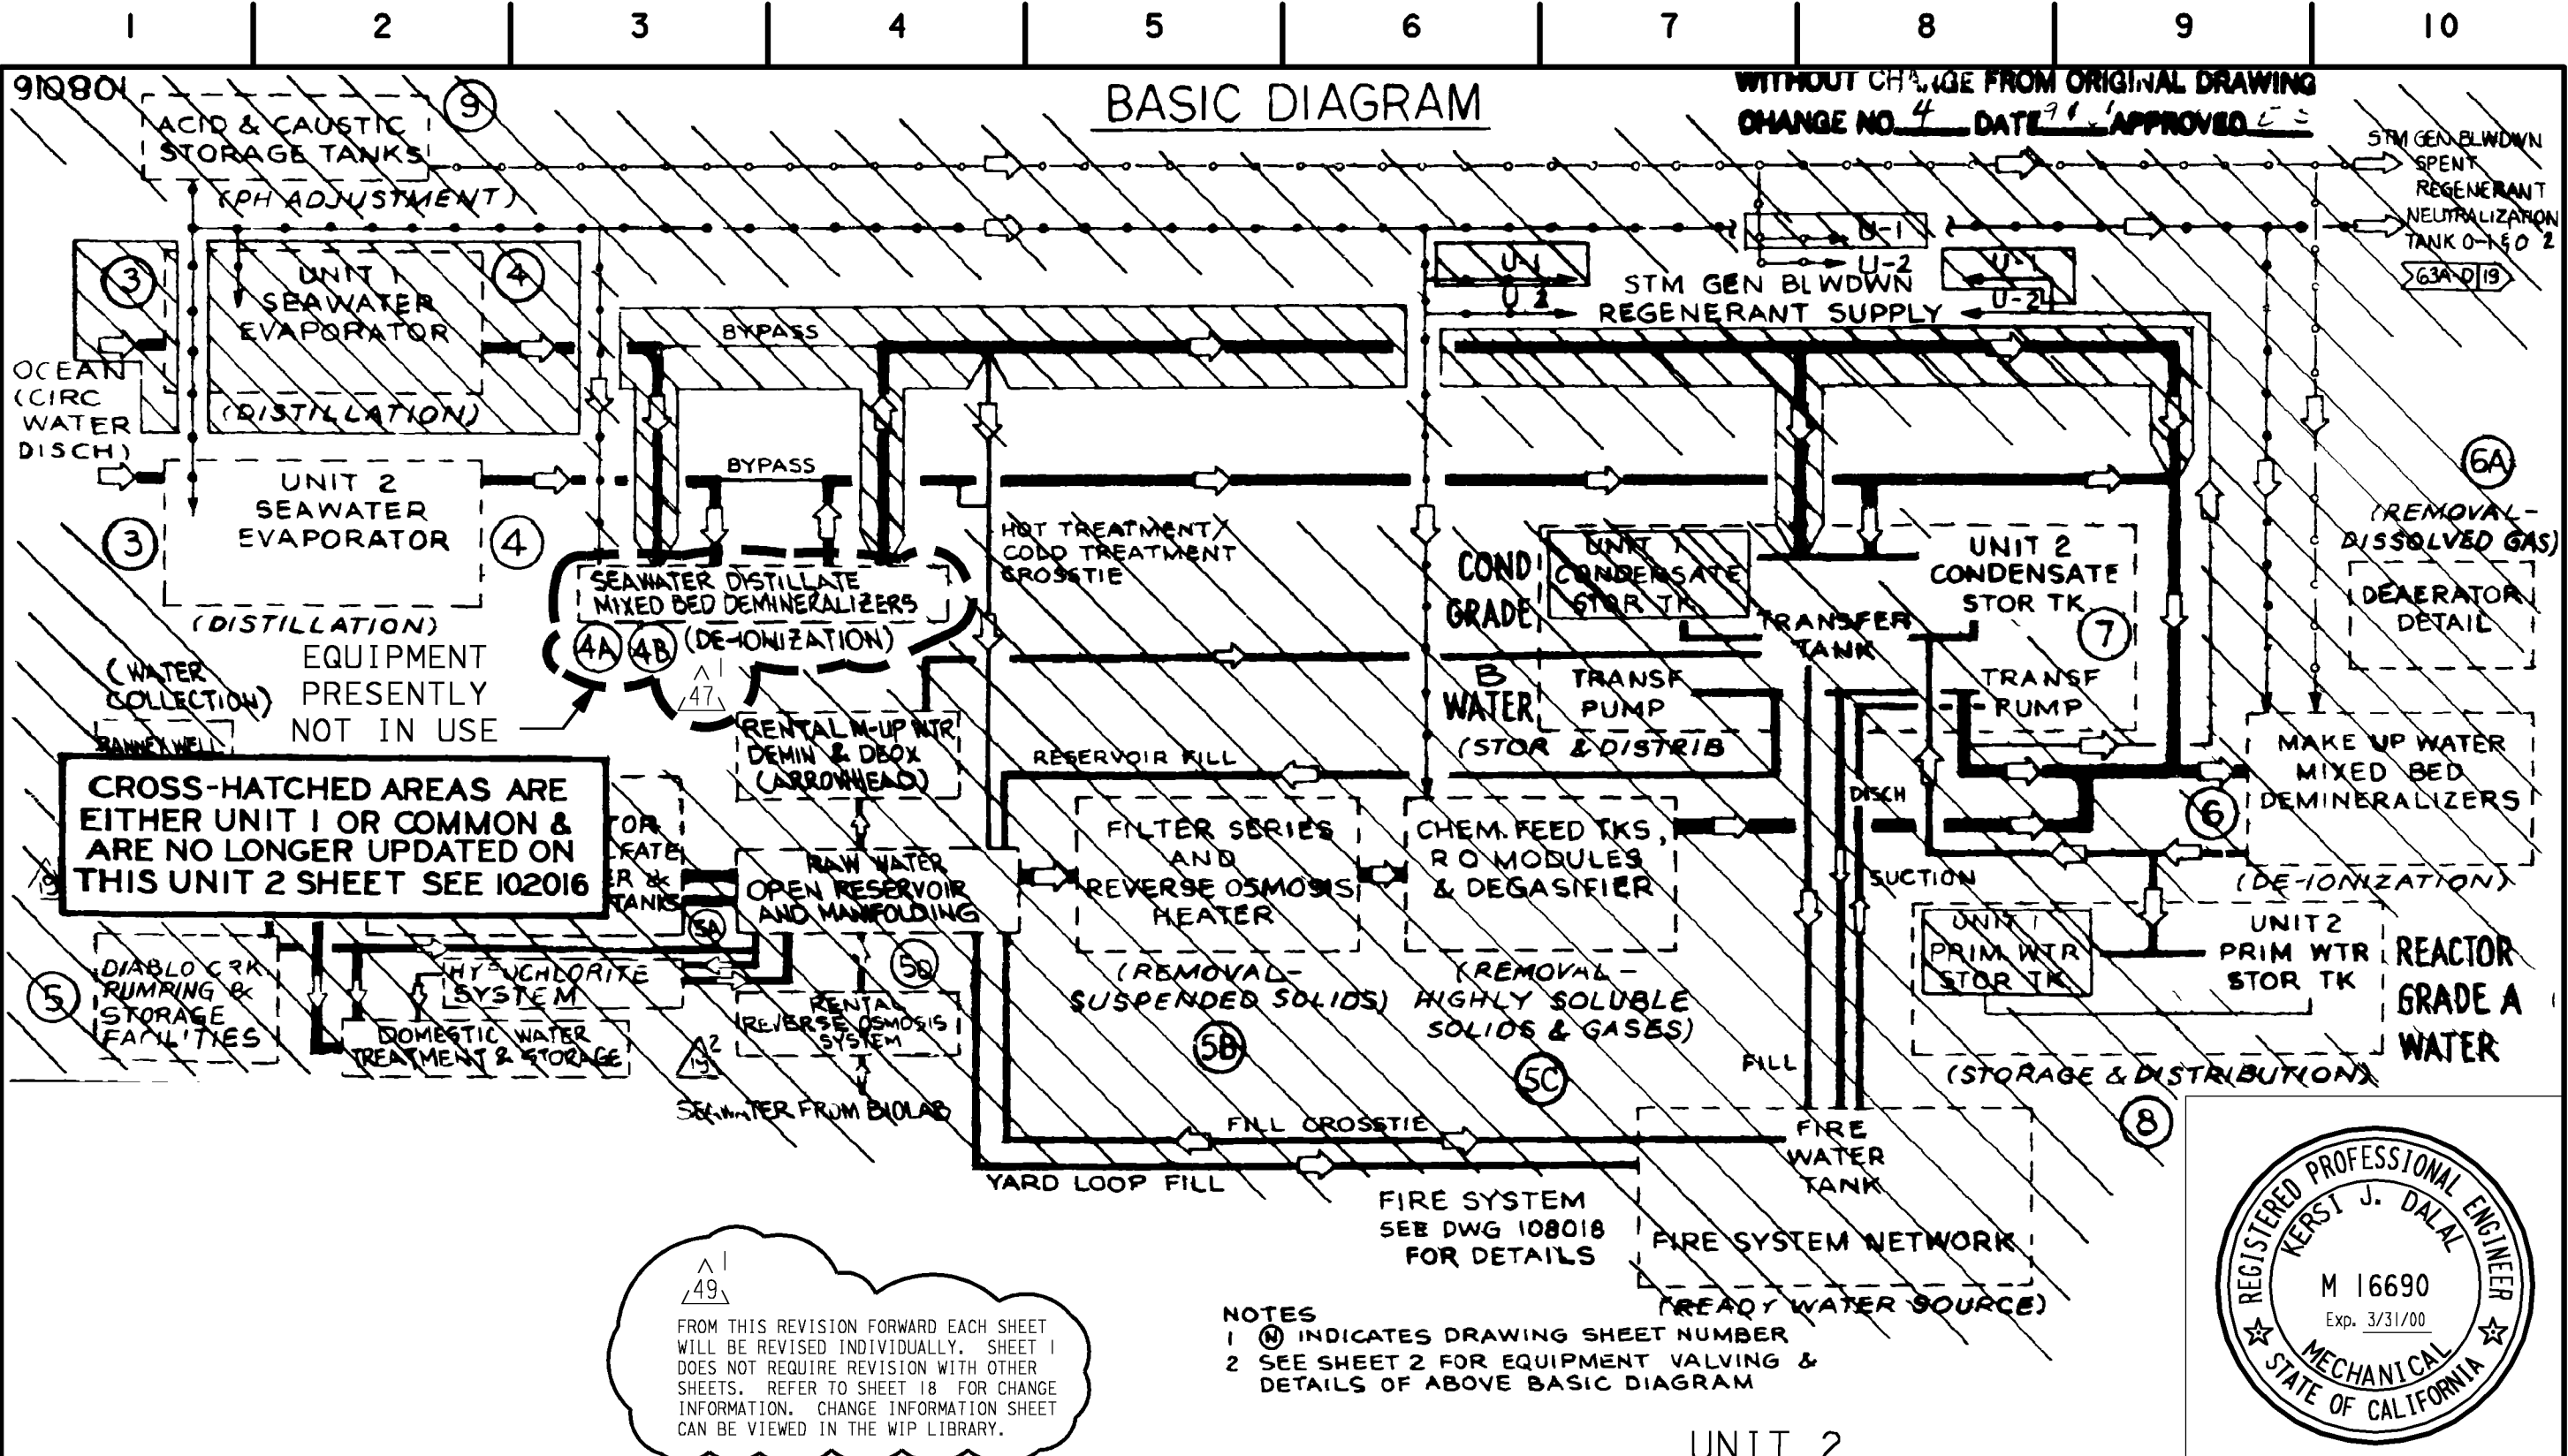

**BASIC DIAGRAM**

WITHOUT CHANGE FROM ORIGINAL DRAWING  
 CHANGE NO. 4 DATE 7/31/98 APPROVED [Signature]

**CROSS-HATCHED AREAS ARE EITHER UNIT 1 OR COMMON & ARE NO LONGER UPDATED ON THIS UNIT 2 SHEET SEE 102016**

FROM THIS REVISION FORWARD EACH SHEET WILL BE REVISED INDIVIDUALLY. SHEET 1 DOES NOT REQUIRE REVISION WITH OTHER SHEETS. REFER TO SHEET 18 FOR CHANGE INFORMATION. CHANGE INFORMATION SHEET CAN BE VIEWED IN THE WIP LIBRARY.

- NOTES**  
 1 (9) INDICATES DRAWING SHEET NUMBER  
 2 SEE SHEET 2 FOR EQUIPMENT VALVING & DETAILS OF ABOVE BASIC DIAGRAM



**UNIT 2**

DATE		DESCRIPTION	COORDINATION	
7/31/98			NUCL.	-
DWN.	PMH2	Revised per FCT 023239	MECH.	-
R.E.	BSG1		ELEC.	-
INDEP. VERIFIER	-		CIVIL	-
P.E.	KJD3		PIPING	-
			I&C	-

REVISION INFORMATION

PIPING SCHEMATIC  
 MAKE-UP WATER SYSTEM

DIABLO CANYON POWER PLANT  
 PACIFIC GAS AND ELECTRIC COMPANY  
 SAN FRANCISCO, CALIFORNIA

DWG SCALE	
BILL OF MATL	
SUPSDS	
SUPSD BY	
SHEET NO.	OF
<b>108016</b>	<b>49</b>