


- GENERAL NOTES:**
- 1) (P) INDICATES PUMPED DOMESTIC WATER LINES
 - 2) (G) INDICATES GRAVITY DOMESTIC WATER LINES
 - 3) [] AND (T) INDICATES BUILDING THAT ARE TEMPORARY FACILITIES
 - 4) [] INDICATES PERMANENT FACILITY (BLDG. NO. 115)
 - 5) FOR ADDITIONAL VALVE TRAIN OF EACH BUILDING SEE BUILDING PLUMBING DRAWING FOR DETAIL.
 - 6) FOR BFP INFORMATION REFER TO DWG. NO. 521764.
 - 7) THE USE OF "PRESS CONNECT" FITTINGS IS ACCEPTABLE FOR DOMESTIC WATER SYSTEM REPAIRS IN ACCORDANCE WITH NMOD 60069783.

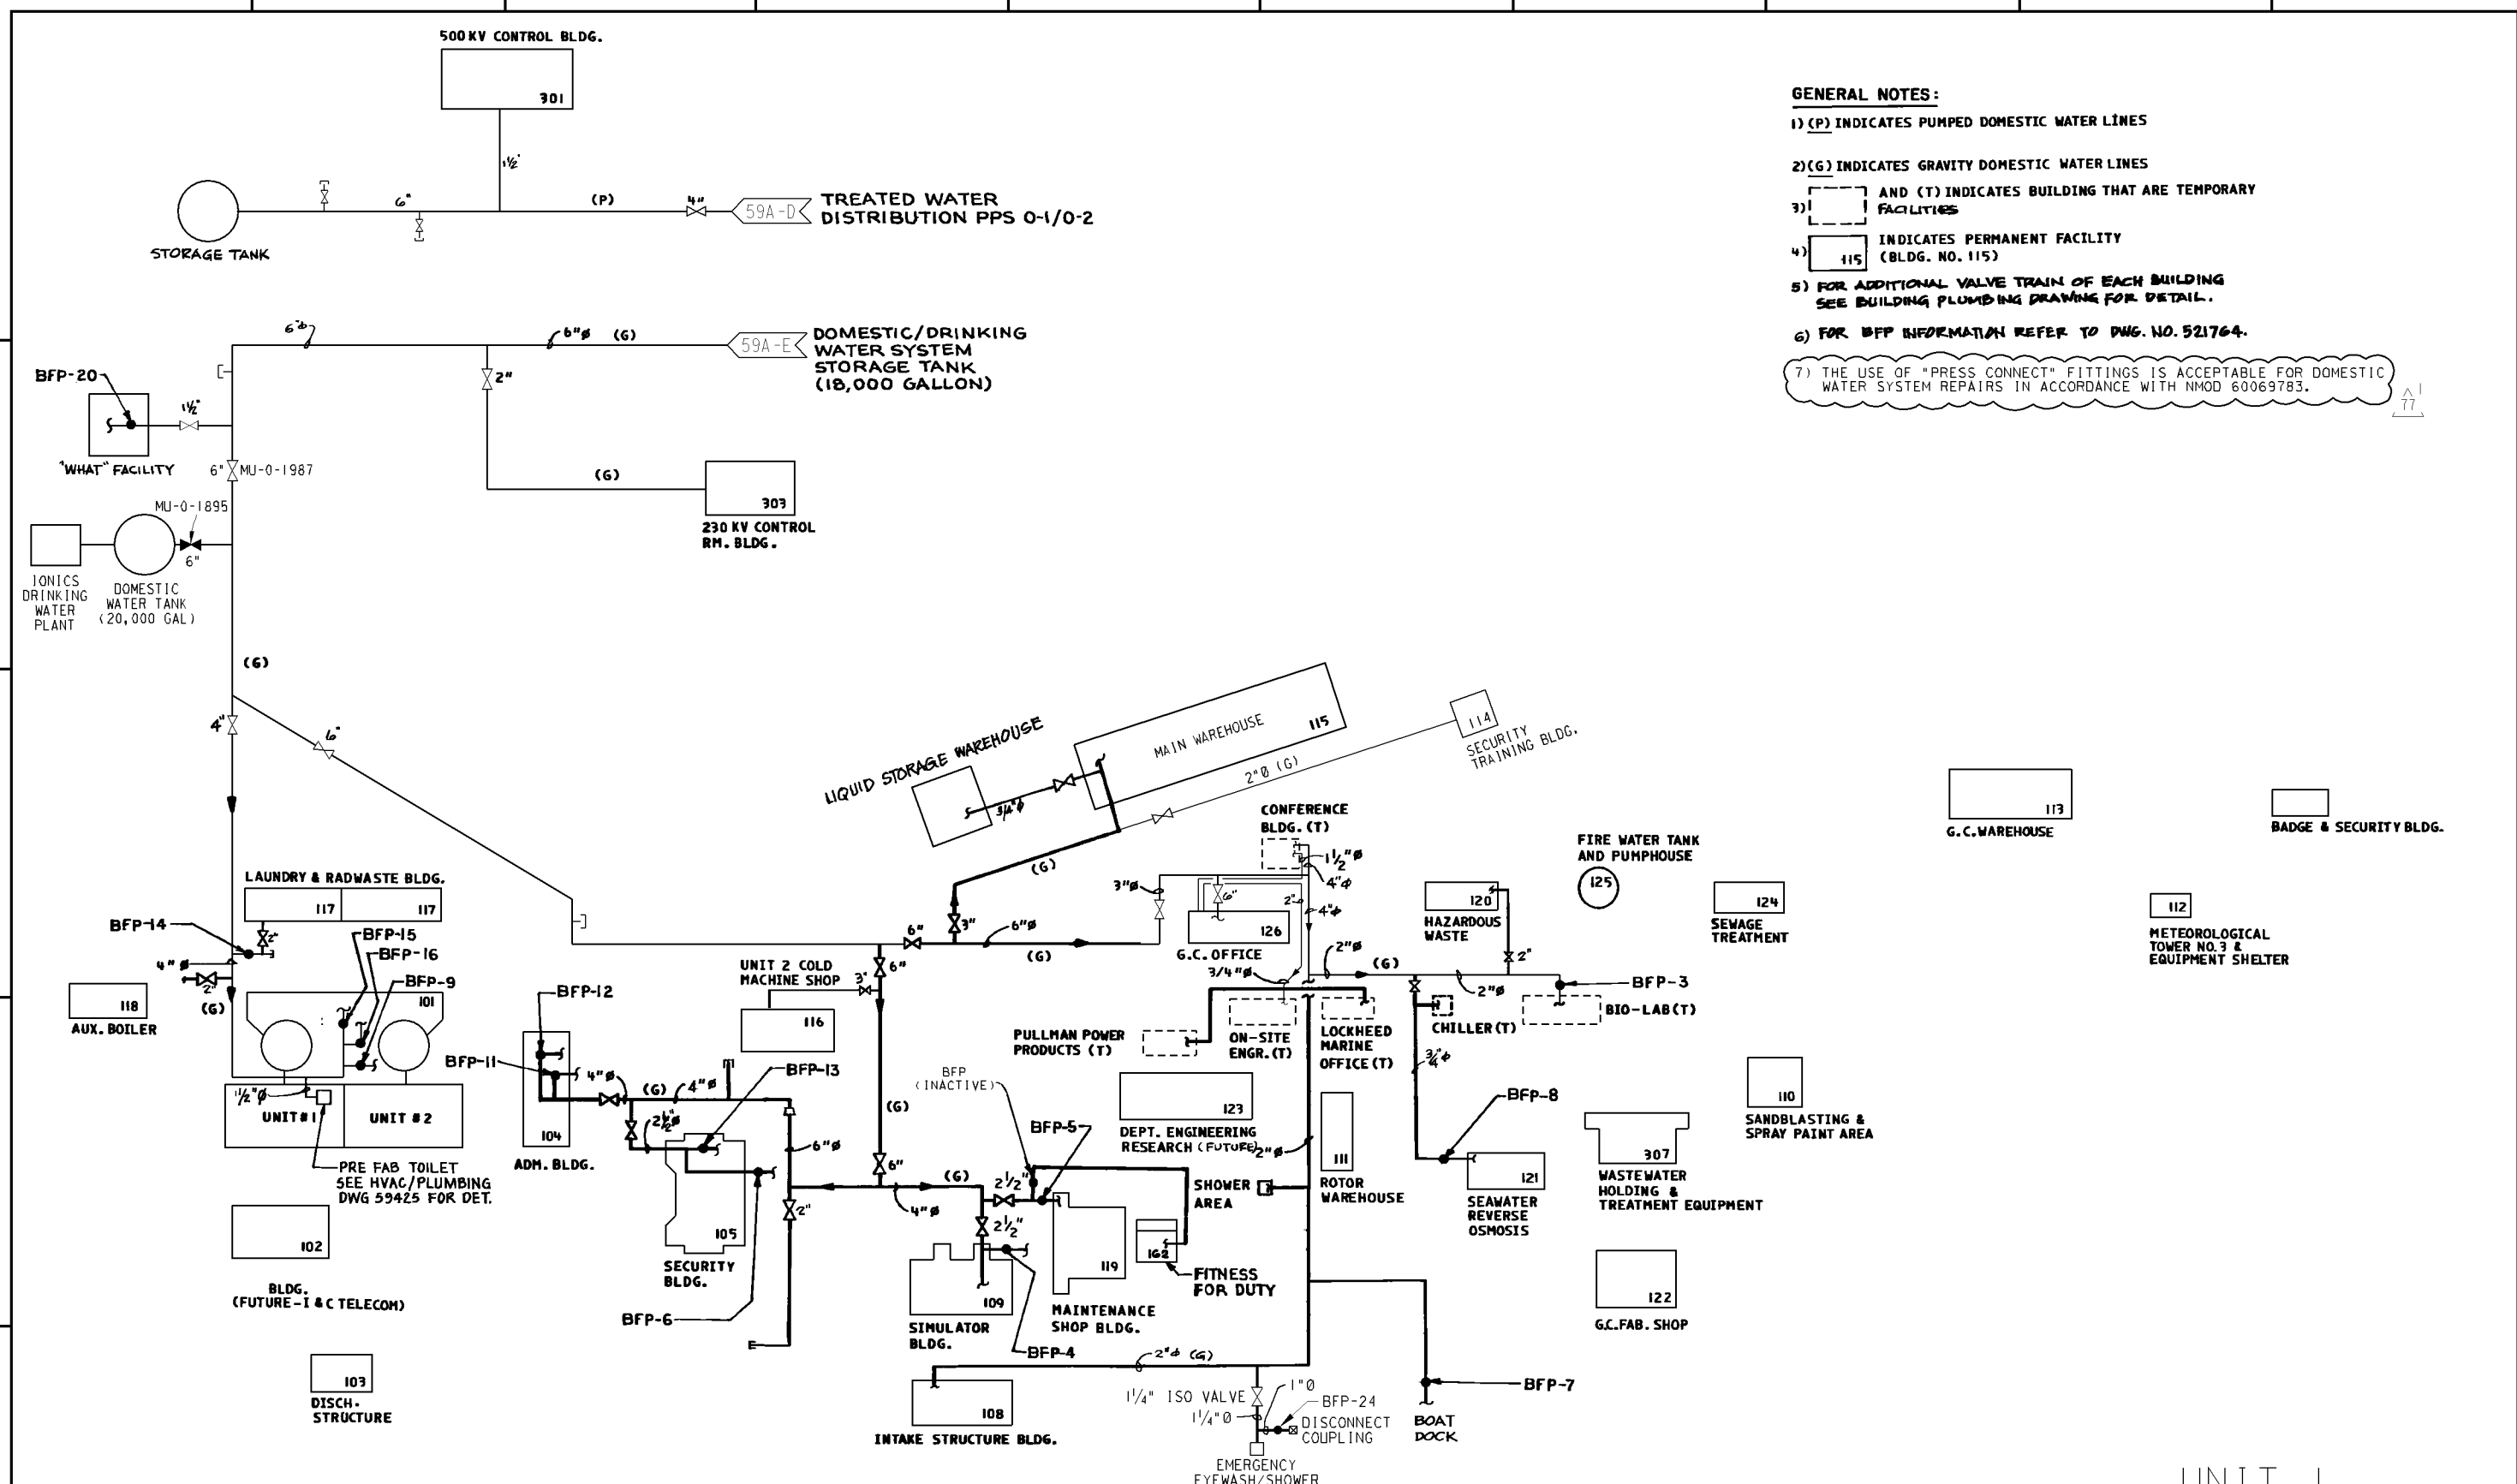

DOMESTIC WATER FLOW DIAGRAM FOR DIABLO CANYON POWER PLANT

UNIT I

DIABLO CANYON POWER PLANT - PG&E CO.
MAKE-UP WATER SYSTEM

DRAWING	SHEET	PAGE	REV
102016	9A	0	77

RASTER=2016s9a.dgn
 DGN=2016s9a.dgn
 CAD User: MNRU Date: 07-15-2014

INPGIC	07-15-2014	MNRU	Fxc2	KJD3	NOT REQUIRED PER CF3.ID5	-	-	-	REVISED PER DDT-4*1077
1 Size	DATE	DWN	RE	IV	PROFESSIONAL ENGINEER	PE DISC.	PE#	PE EXP.	