




NOTES

1. ALL PIPING WITH PG&E CLASS 'G' IS UNDER SPEC. 8831, EXCEPT AS NOTED.
2. ALL PIPING WITH PG&E CLASS 'B', 'E' & 'G1' IS UNDER SPEC. 8711.
3. EACH RCP HAS 5 SPRINKLER HEADS FOR FIRE PROTECTION (75-C)
4. ALL HOSE REELS HAVE RESTRICTING ORIFICES (REF. DWG. 060831.), OR POWHATAN PRESSURE RESTRICTING VALVE 18-255 OR EQUIV.
5. 3/4" GATE VALVE, VELAN, DWG. NO 6006473-166, STOCK CODE 93-6841 (72-C)

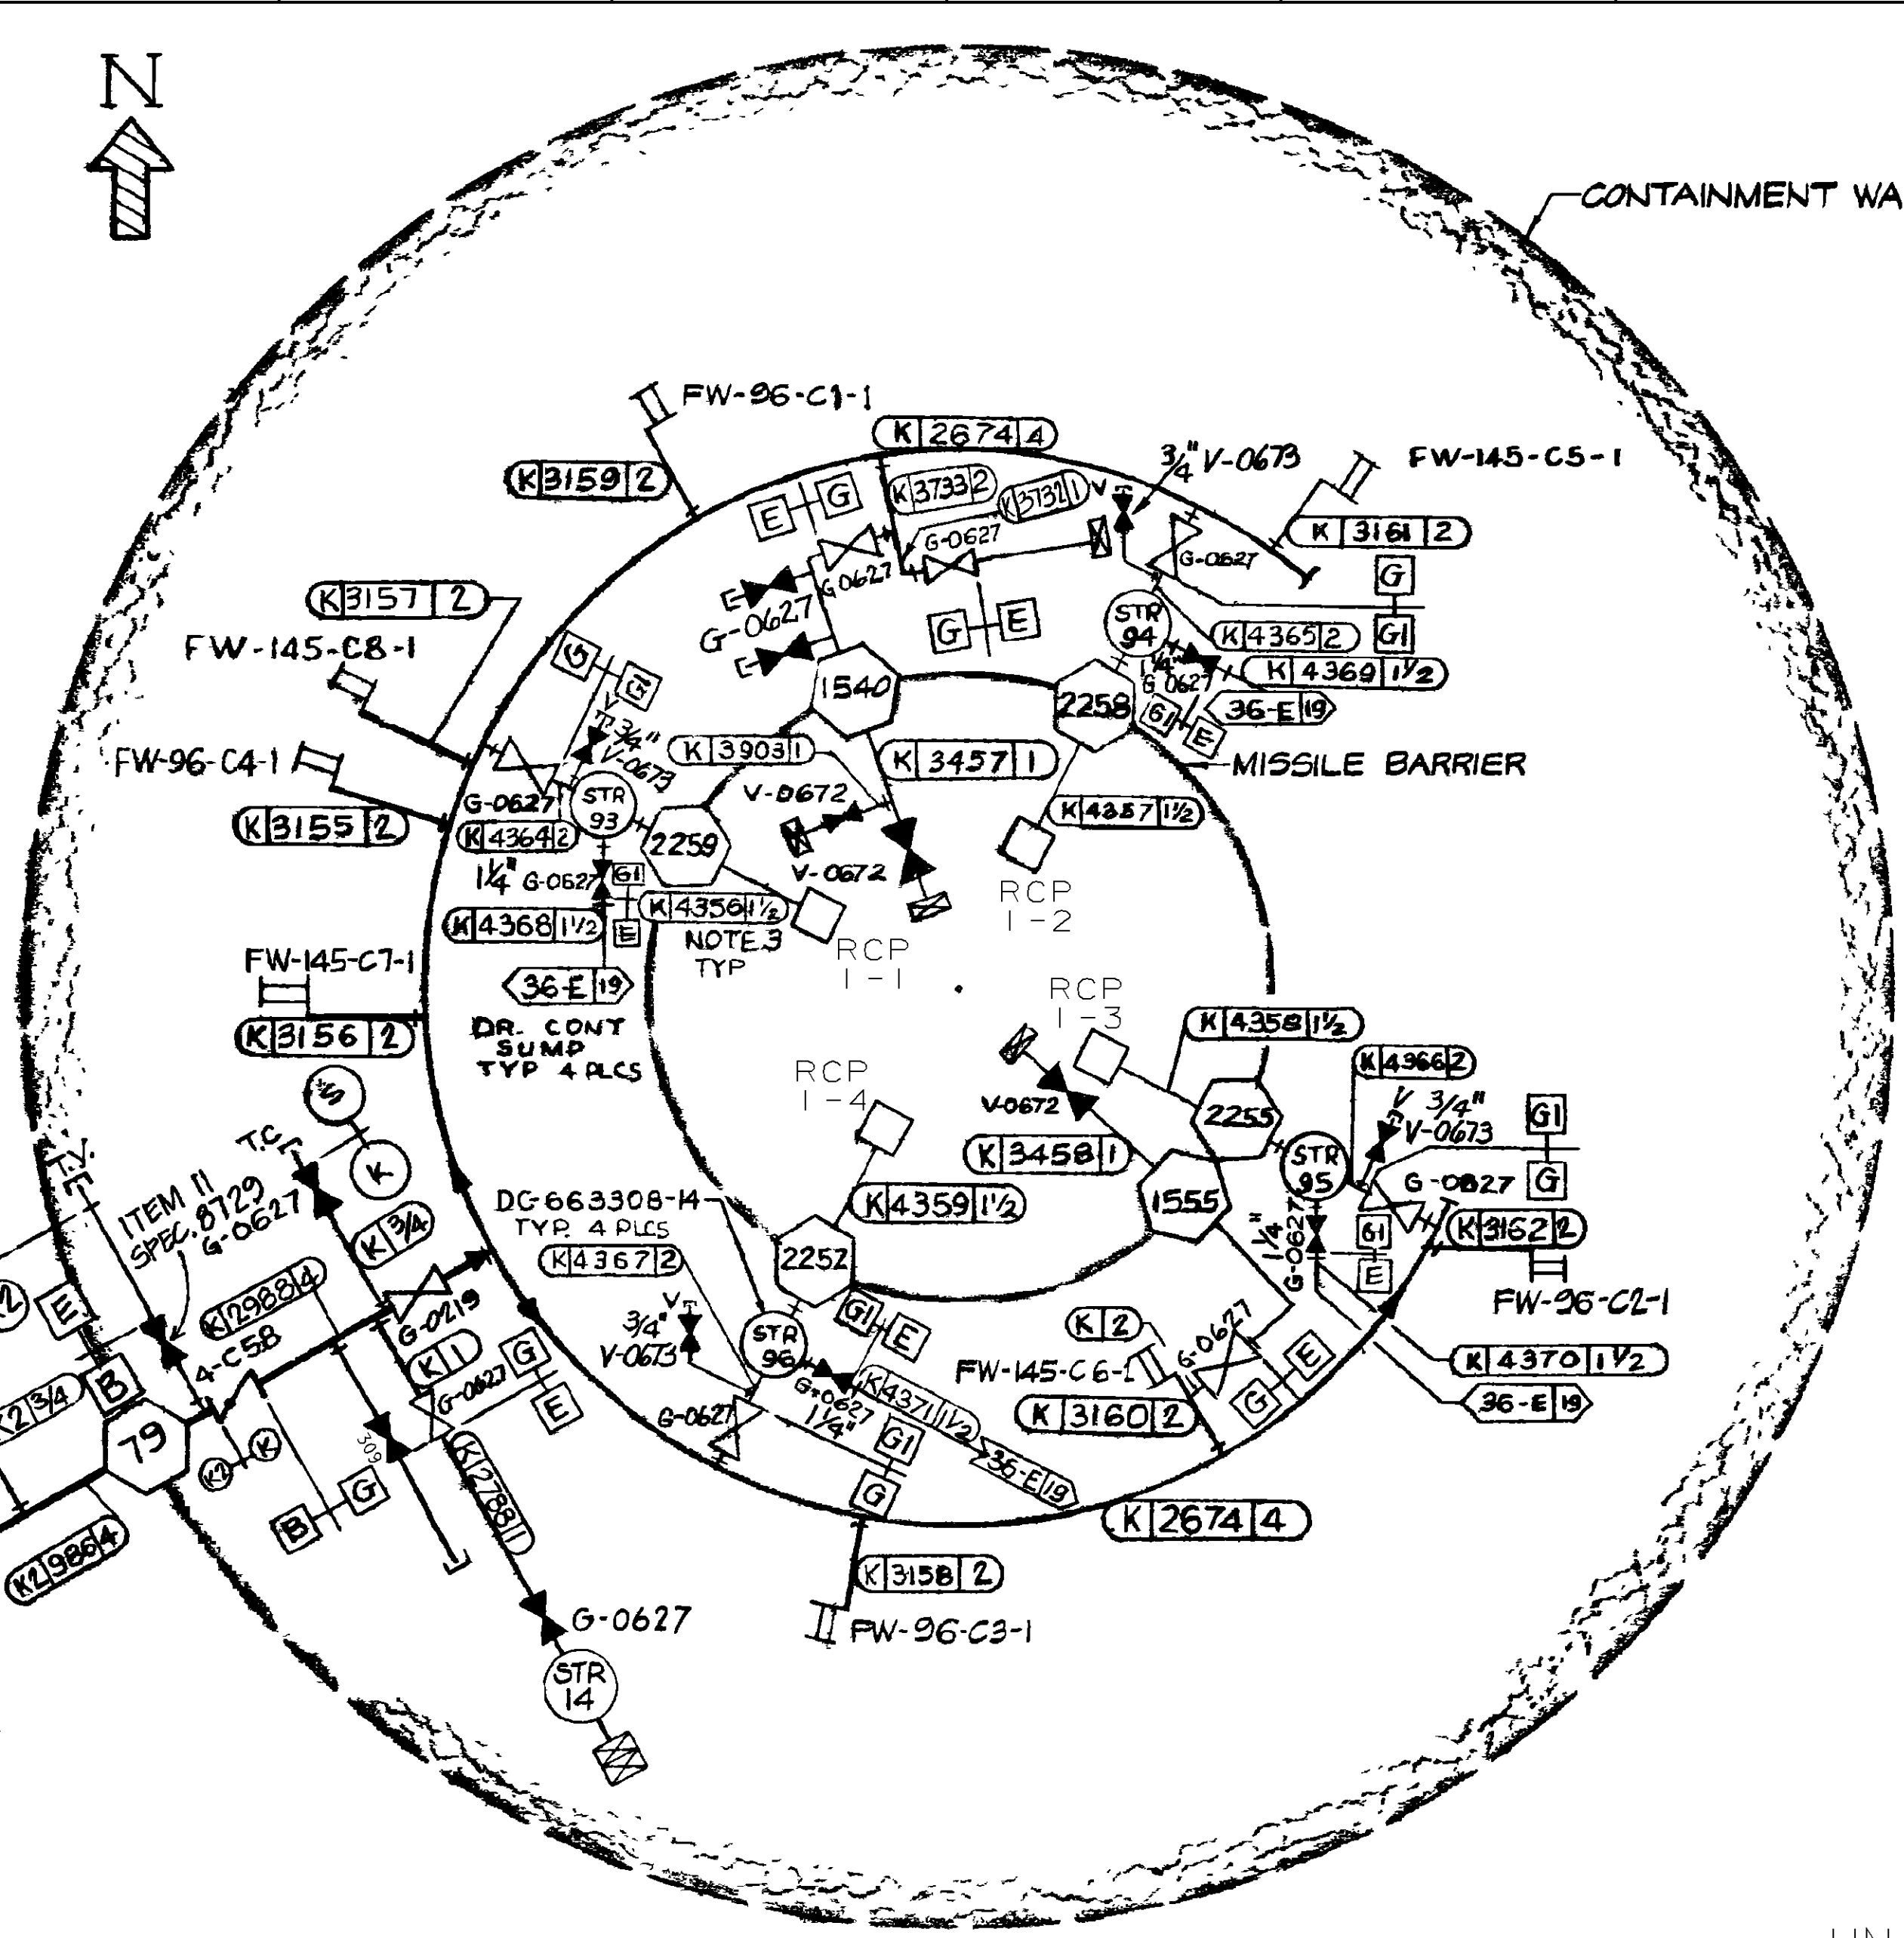

CONTAINMENT STRUCTURE

UNIT I

DIABLO CANYON POWER PLANT - PG&E CO.			
FIRE PROTECTION SYSTEMS			
DRAWING	SHEET	PAGE	REV
102018	7	0	64

RASTER=102018s7.DGN
 DGN=102018s7.DGN
 CAD User: ZNS4 Date: 10-15-2015

INPG2ND
1 Size

10-15-2015	ZNS4	Fxc2	N/A	NOT REQUIRED PER CF3.ID5	-	-	-	REVISED PER DDT-4*1197
DATE	DWN	RE	IV	PROFESSIONAL ENGINEER	PE DISC.	PE#	PE EXP.	