


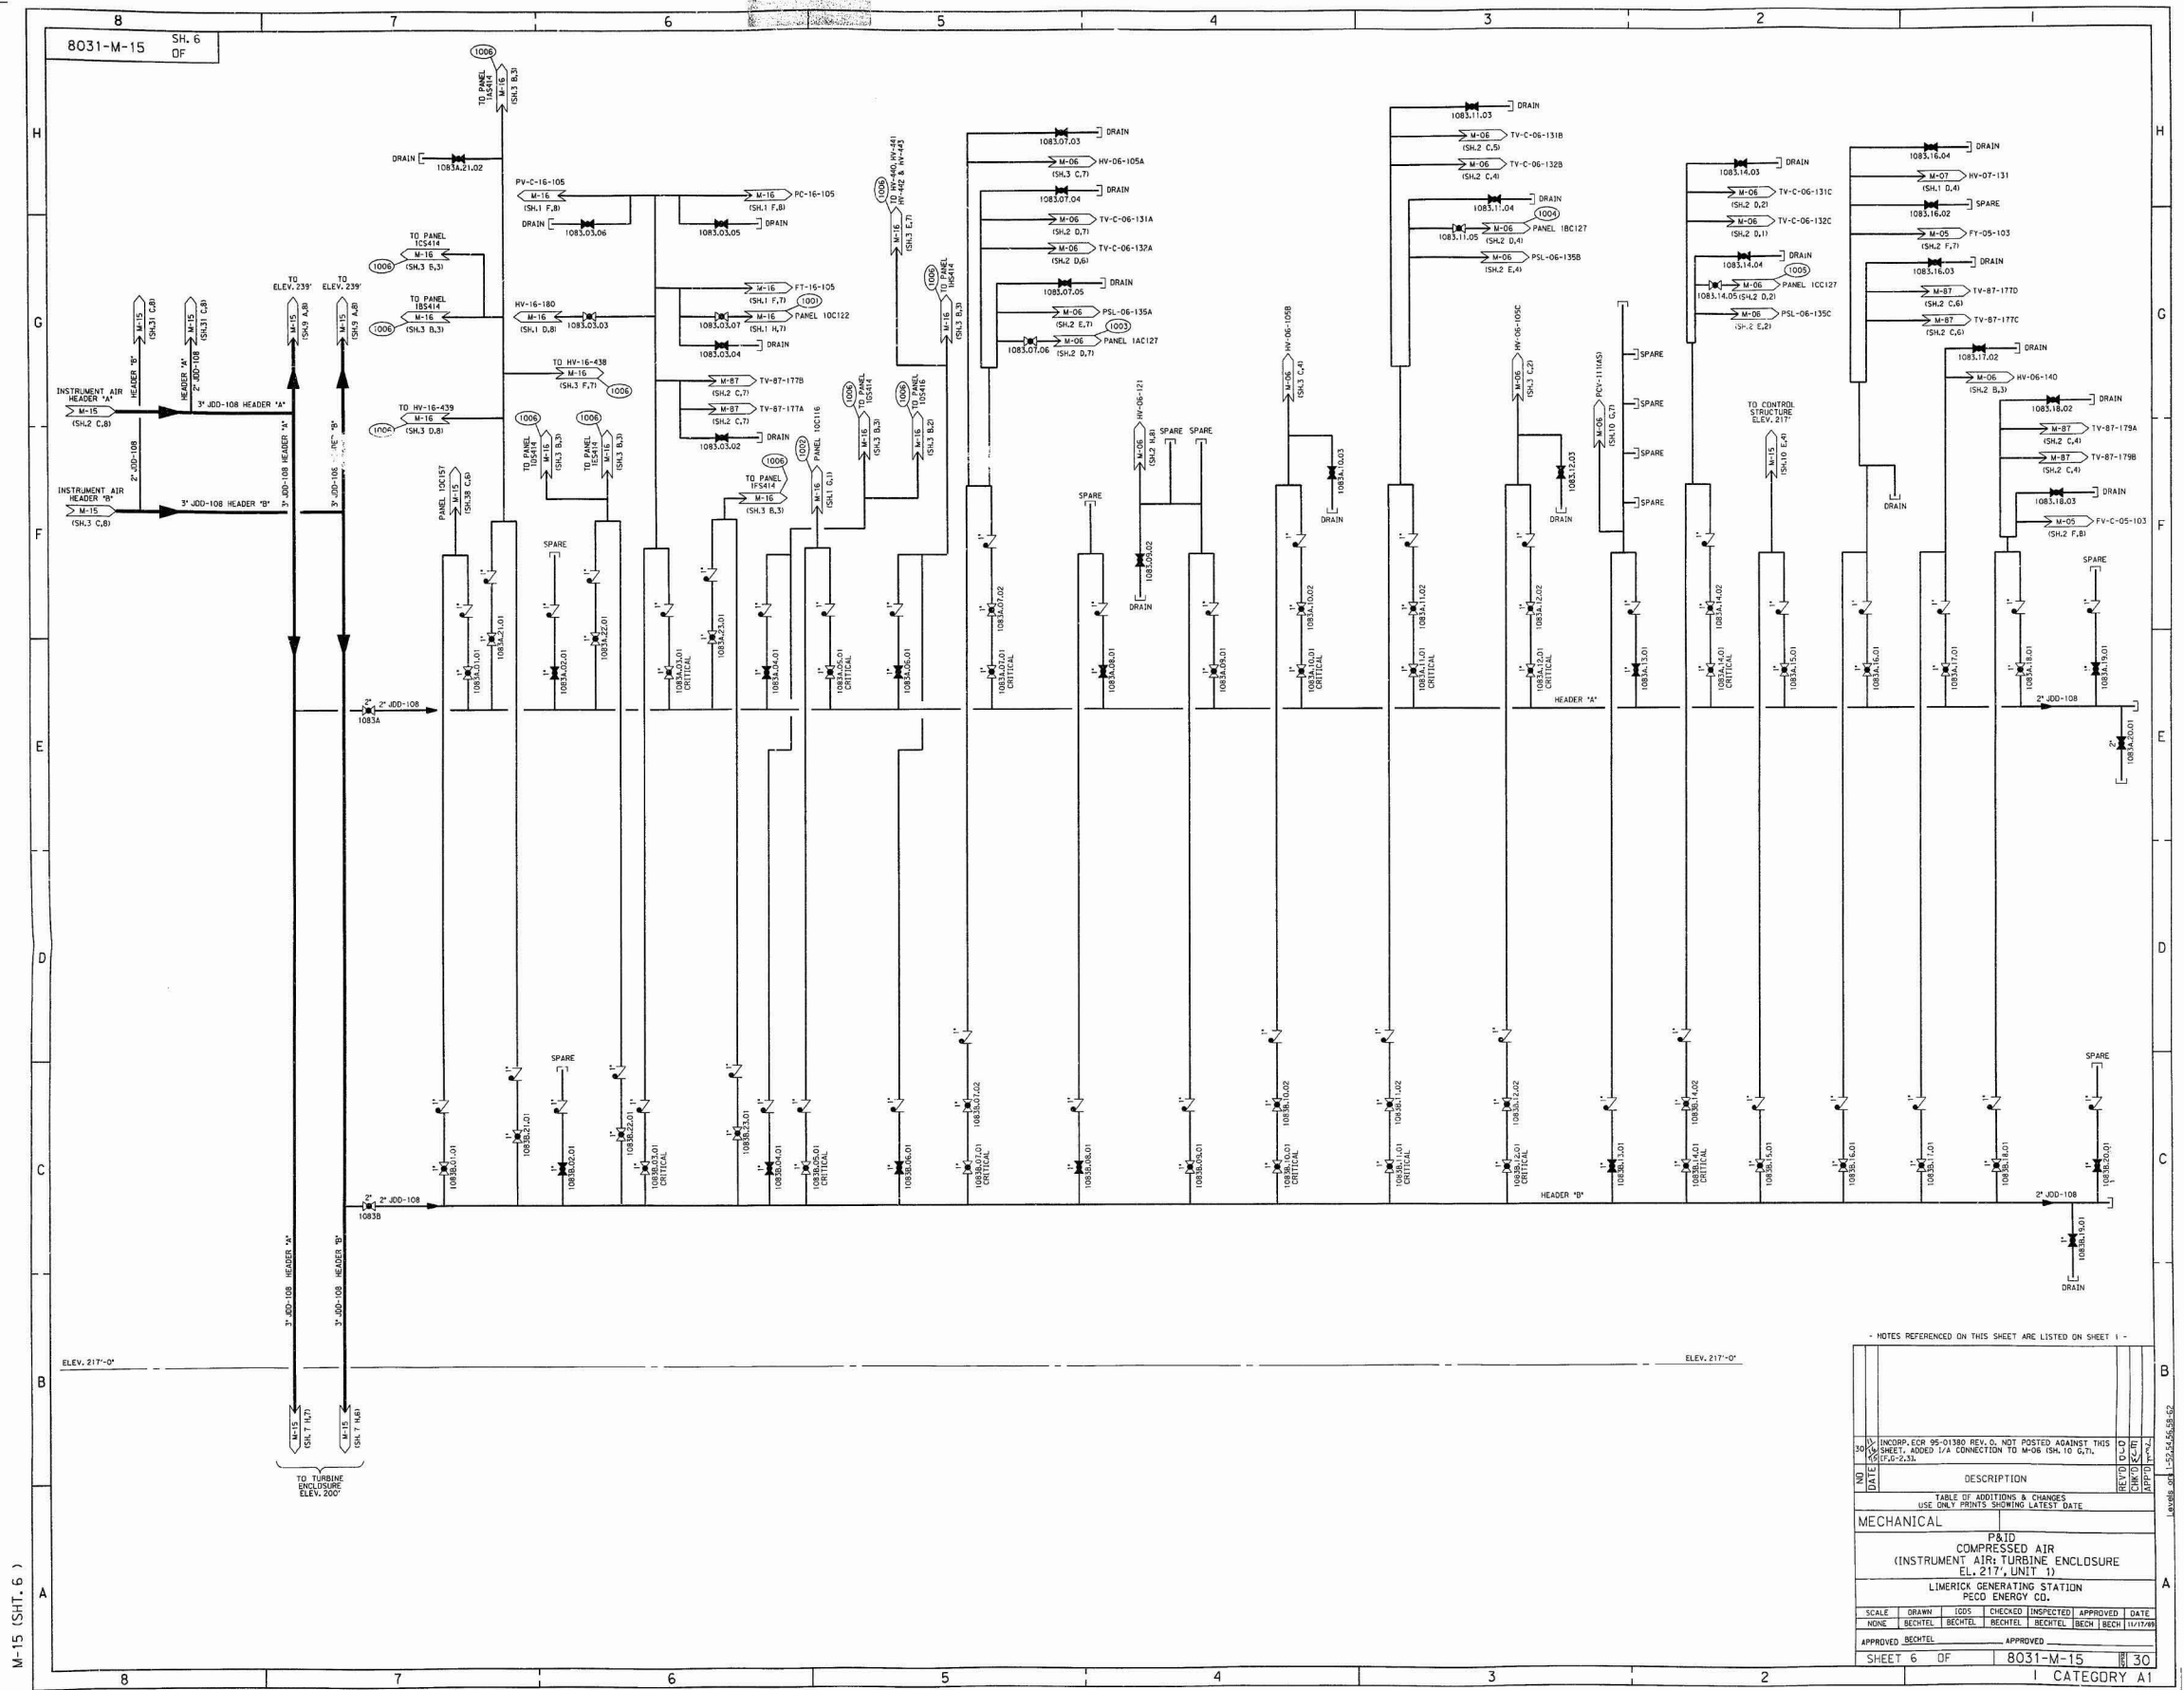

NOTES REFERENCED ON THIS SHEET ARE LISTED ON SHEET 1 -			
NO	DATE	DESCRIPTION	BY
30	10/10/99	INCORP. ECR 95-01380 REV. 0, NOT POSTED AGAINST THIS SHEET, ADDED 1/4 CONNECTION TO M-06 (SH. 10 G, 7).	CHD/ELD
TABLE OF ADDITIONS & CHANGES			
USE ONLY PRINTS SHOWING LATEST DATE			
MECHANICAL			
P&ID			
COMPRESSED AIR			
(INSTRUMENT AIR TURBINE ENCLOSURE			
EL. 217, UNIT 1)			
LIMERICK GENERATING STATION			
PECO ENERGY CO.			
SCALE	DRAWN	LOGS	CHECKED
NONE	BECHTEL	BECHTEL	BECHTEL
APPROVED			
SHEET 6 OF 8031-M-15			
I CATEGORY A1			