
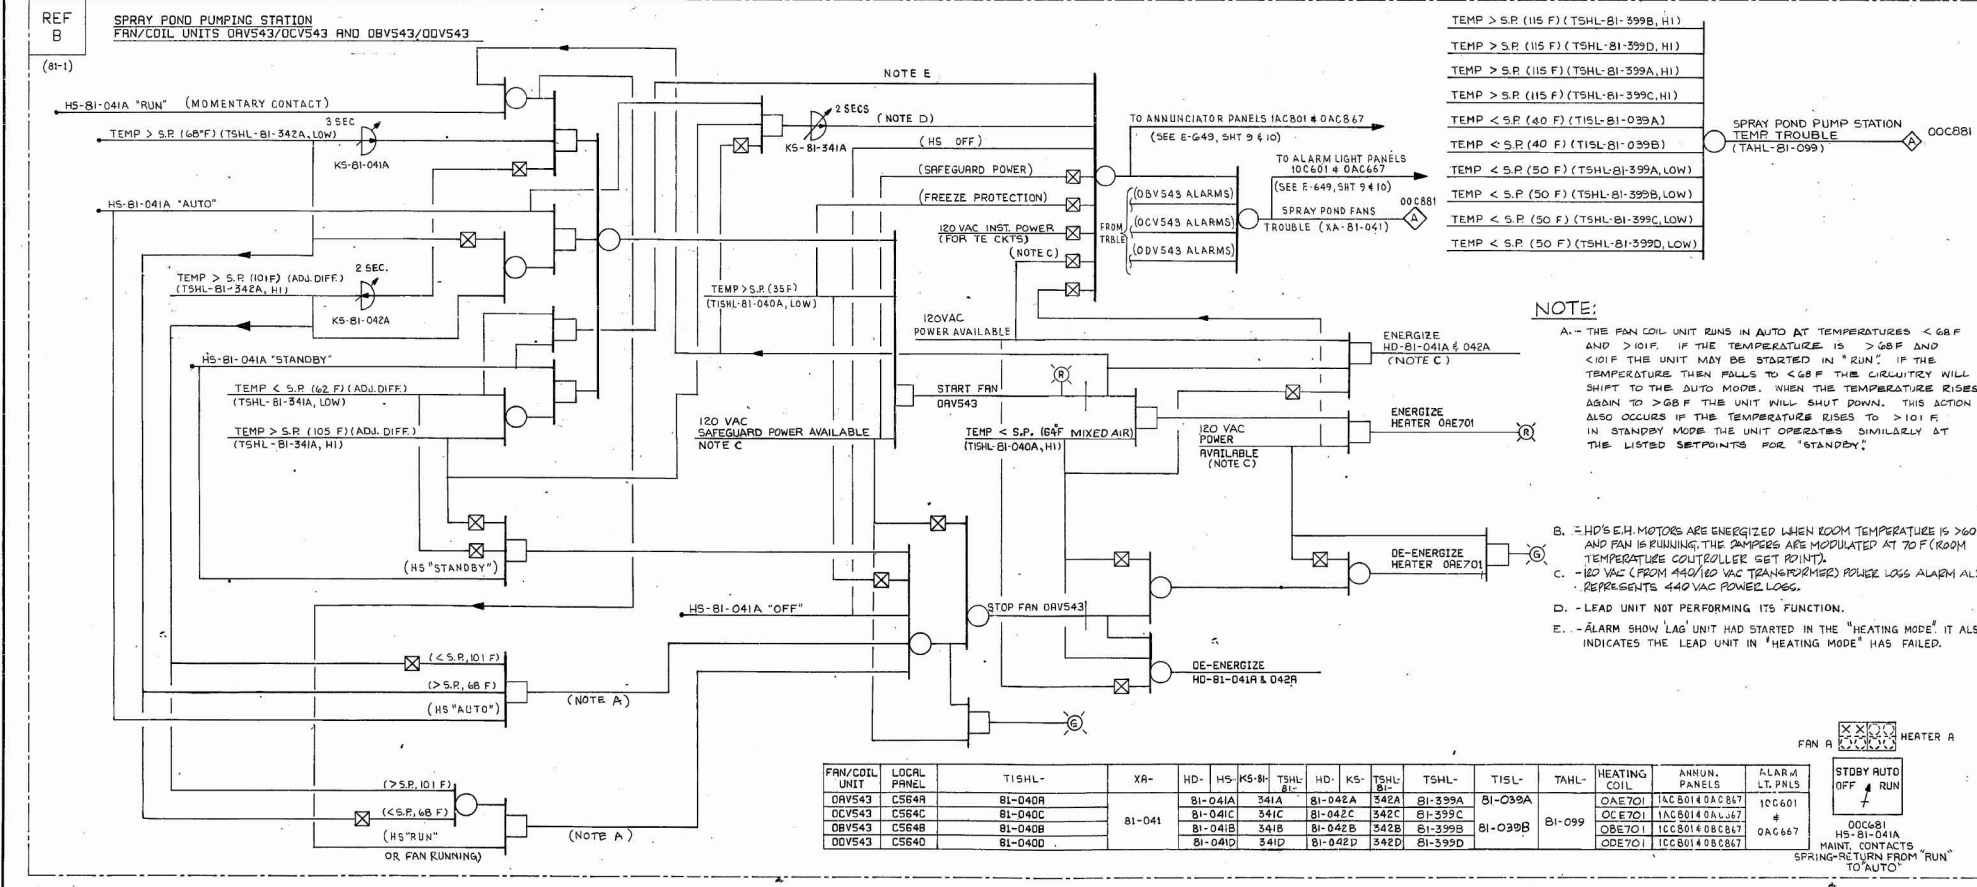


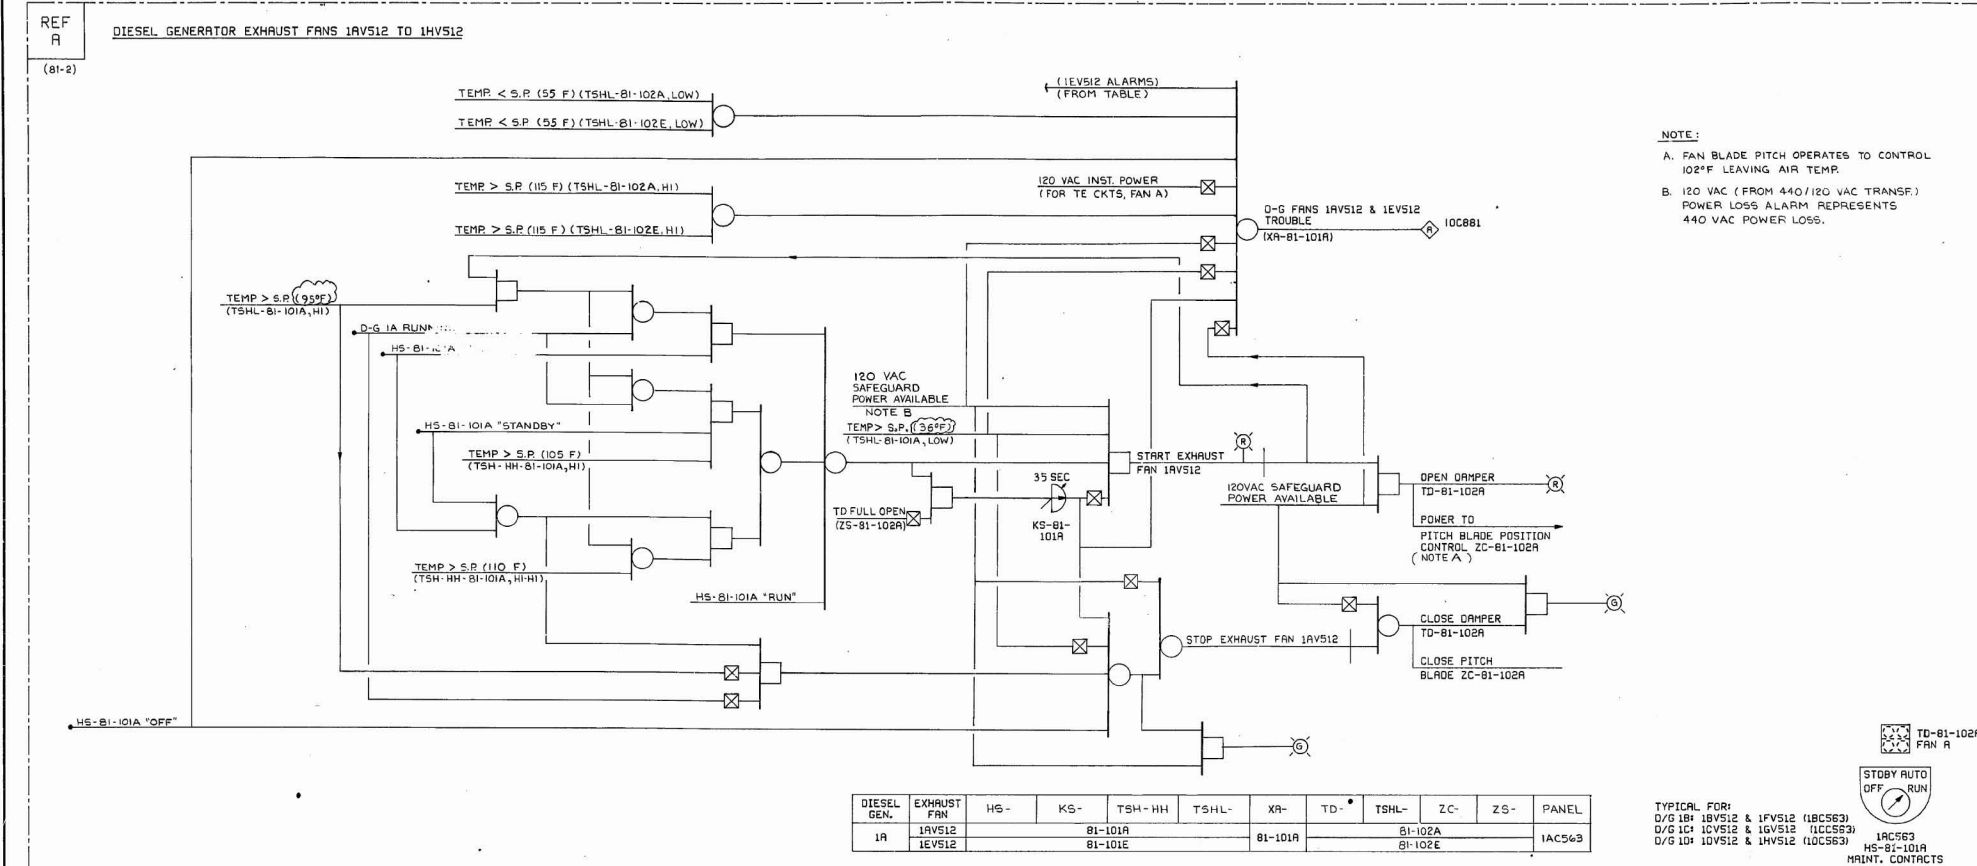

NOTES:
1. THIS FUNCTIONAL DESCRIPTION DRAWING IS BASED ON P & ID M-81, SHT. 1 REV.10.

REFERENCE SCHEMATIC DRAWINGS

REF. NO.	DWG. NO.	TITLE
A	E490	DIESEL GENERATOR VENTILATION AIR EXHAUST FANS AND AUXILIARY CONTROL - UNITS 1 & 2
B	E491-1-3	SPRAY POND PUMP STRUCTURE FAN, HEATER AND AUXILIARY CONTROL - COMMON

BECHTEL
SAN FRANCISCO

LIMERICK GENERATING STATION UNITS 1 & 2
PHILADELPHIA ELECTRIC COMPANY

FUNCTIONAL DESCRIPTION
MISCELLANEOUS STRUCTURES- HVAC

JOB NO.	DRAWING NO.	REV.
8031	M-81FD, SHT 1 OF 4	8

REF. A, B