


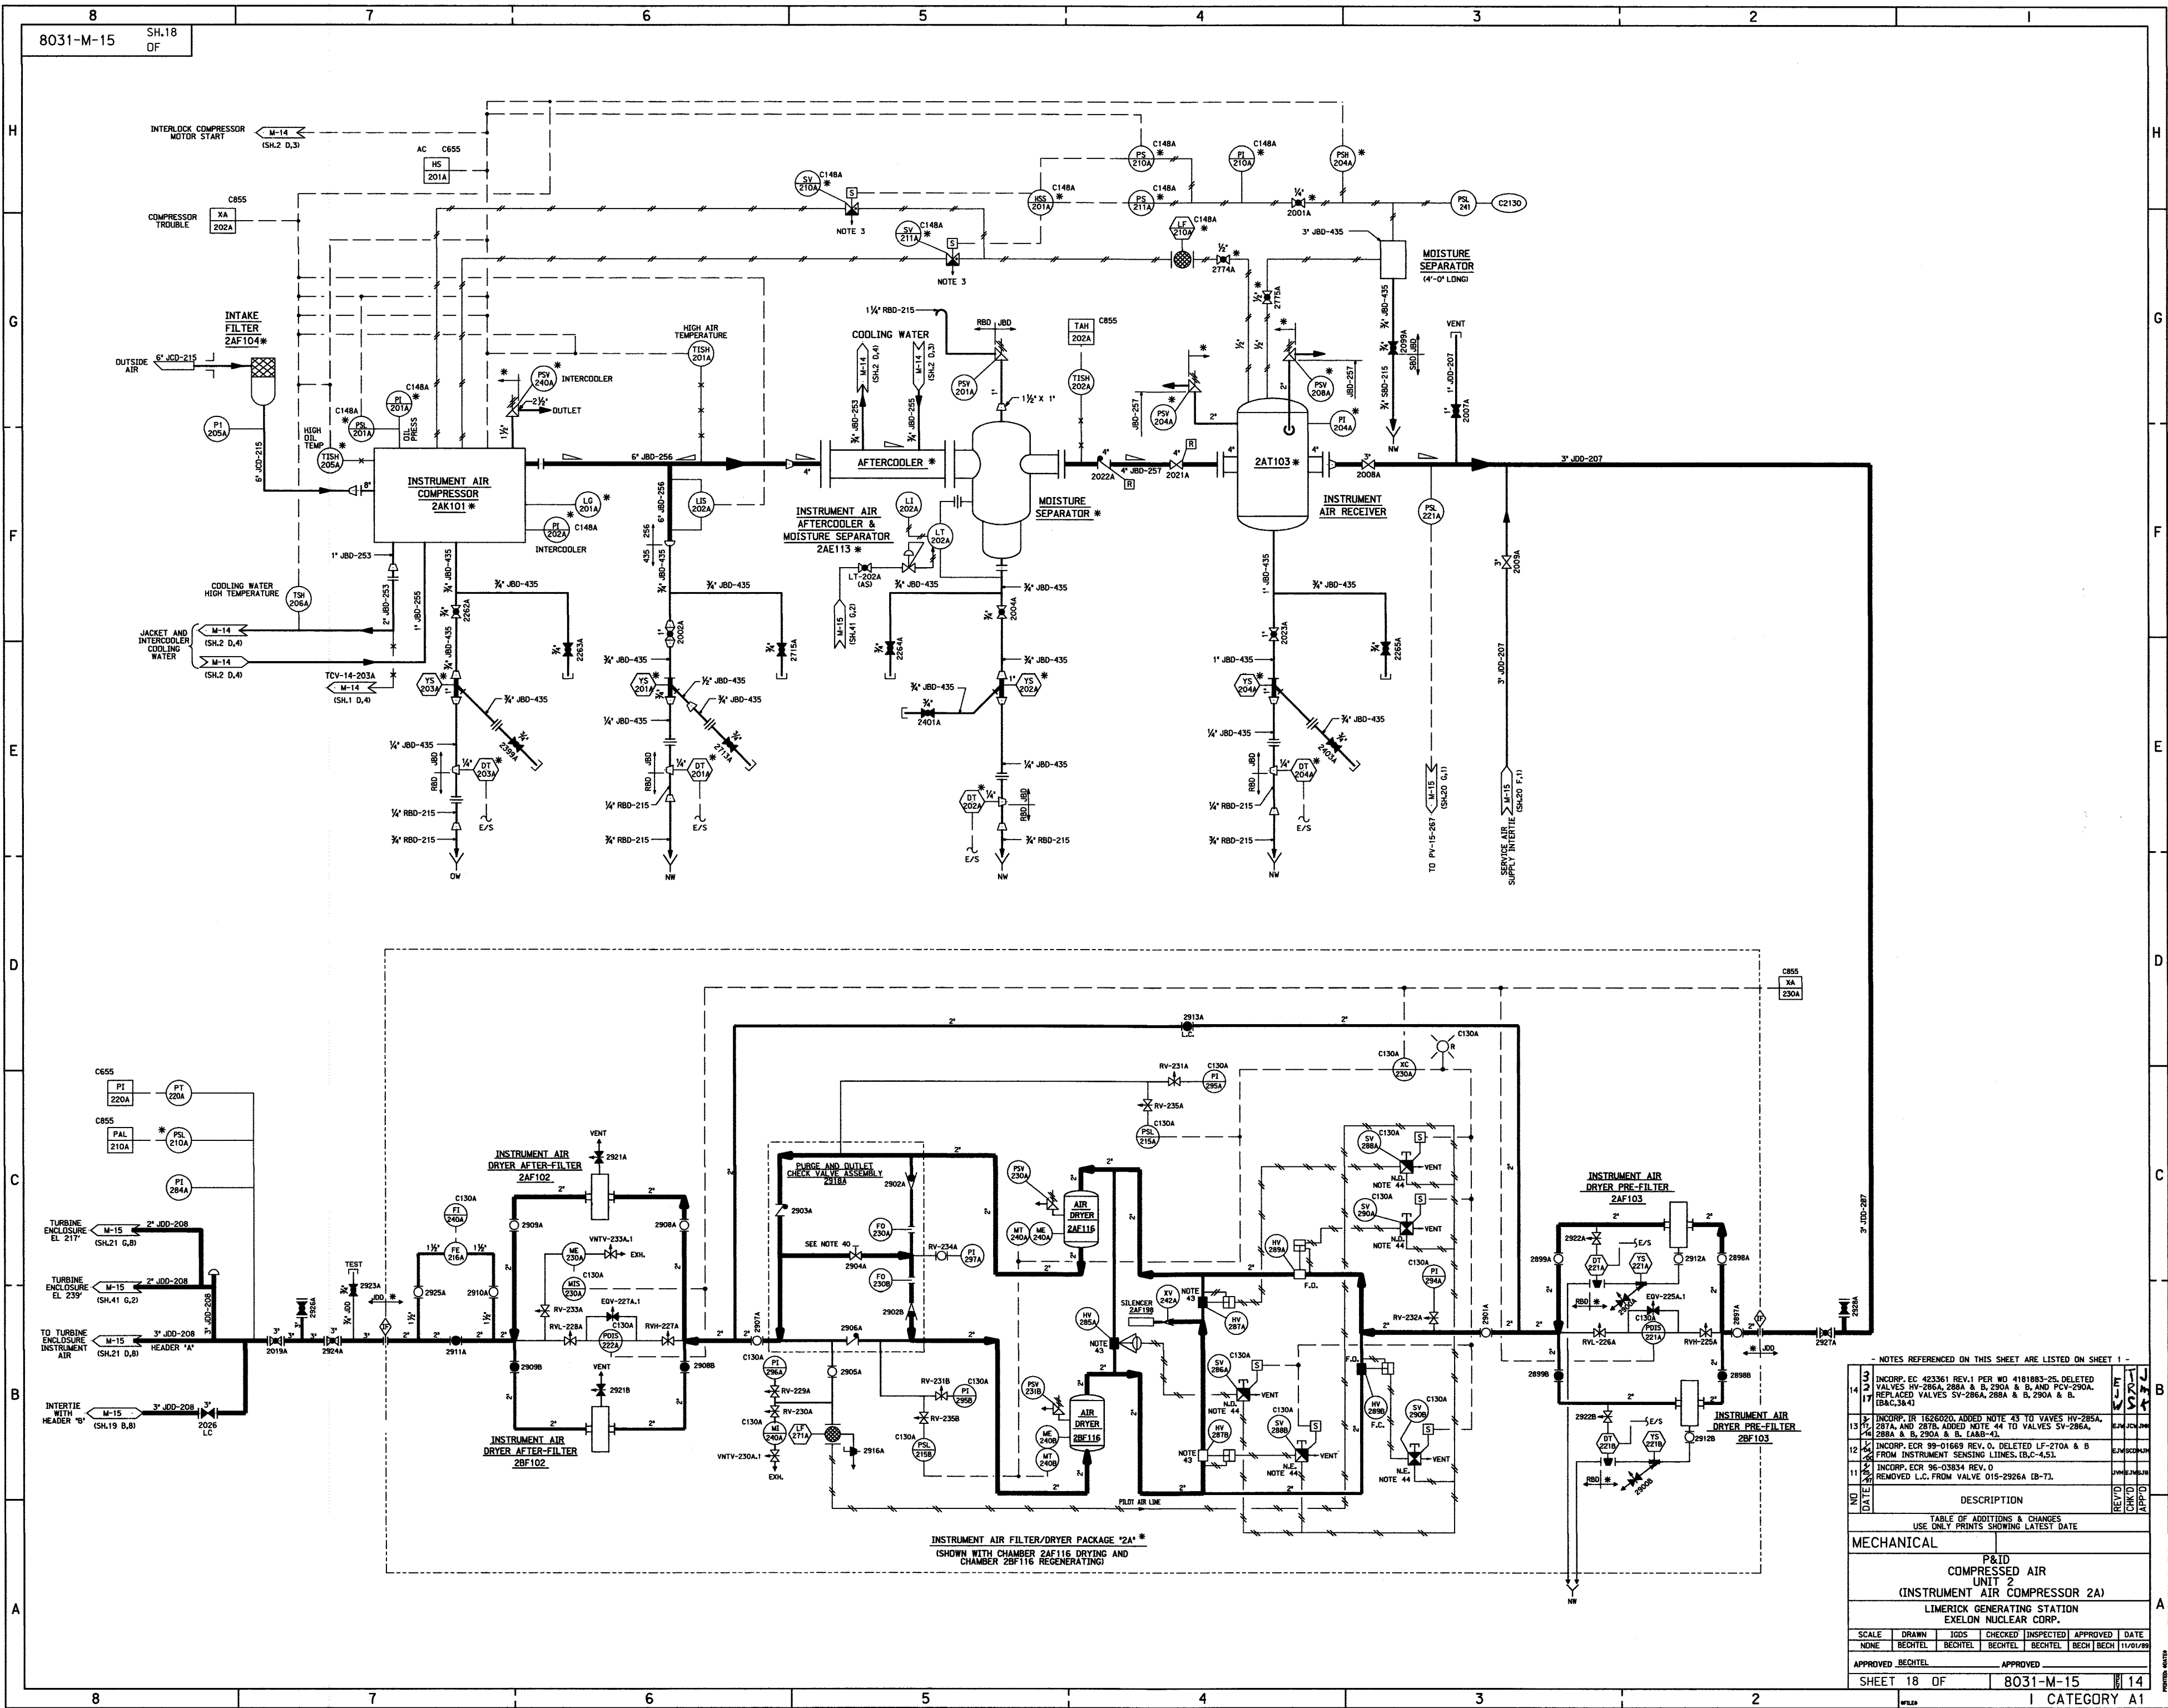

NOTES REFERENCED ON THIS SHEET ARE LISTED ON SHEET 1 -

14	INCORP. EC 42361 REV.1 PER WD 4181883-25, DELETED VALVES HV-286A, 288A & B, 290A & B, AND PCV-290A.	REV'D
17	REPLACED VALVES SV-286A, 288A & B, 290A & B.	REV'D
13	INCORP. IN 1626020, ADDED NOTE 43 TO VALVES HV-285A, 287A, AND 287S, ADDED NOTE 44 TO VALVES SV-286A, 288A & B, 290A & B, (A&B-43).	REV'D
12	INCORP. ECR 99-01669 REV. 0, DELETED LF-270A & B FROM INSTRUMENT SENSING LINES, (B.C-4.5).	REV'D
11	INCORP. ECR 96-03834 REV. 0	REV'D
10	REMOVED L.C. FROM VALVE 015-2926A (B-7).	REV'D

NO.	DATE	DESCRIPTION	BY	CHKD
1		TABLE OF ADDITIONS & CHANGES		
2		USE ONLY PRINTS SHOWING LATEST DATE		

MECHANICAL

P&ID
COMPRESSED AIR
UNIT 2
(INSTRUMENT AIR COMPRESSOR 2A)

LIMERICK GENERATING STATION
EXELON NUCLEAR CORP.

SCALE	DRAWN	IGDS	CHECKED	INSPECTED	APPROVED	DATE
NONE	BECHTEL	BECHTEL	BECHTEL	BECHTEL	BECHTEL	11/01/90

APPROVED: BECHTEL

SHEET 18 OF 8031-M-15 14

I CATEGORY A1