



8031-M-76FD
SHT 5

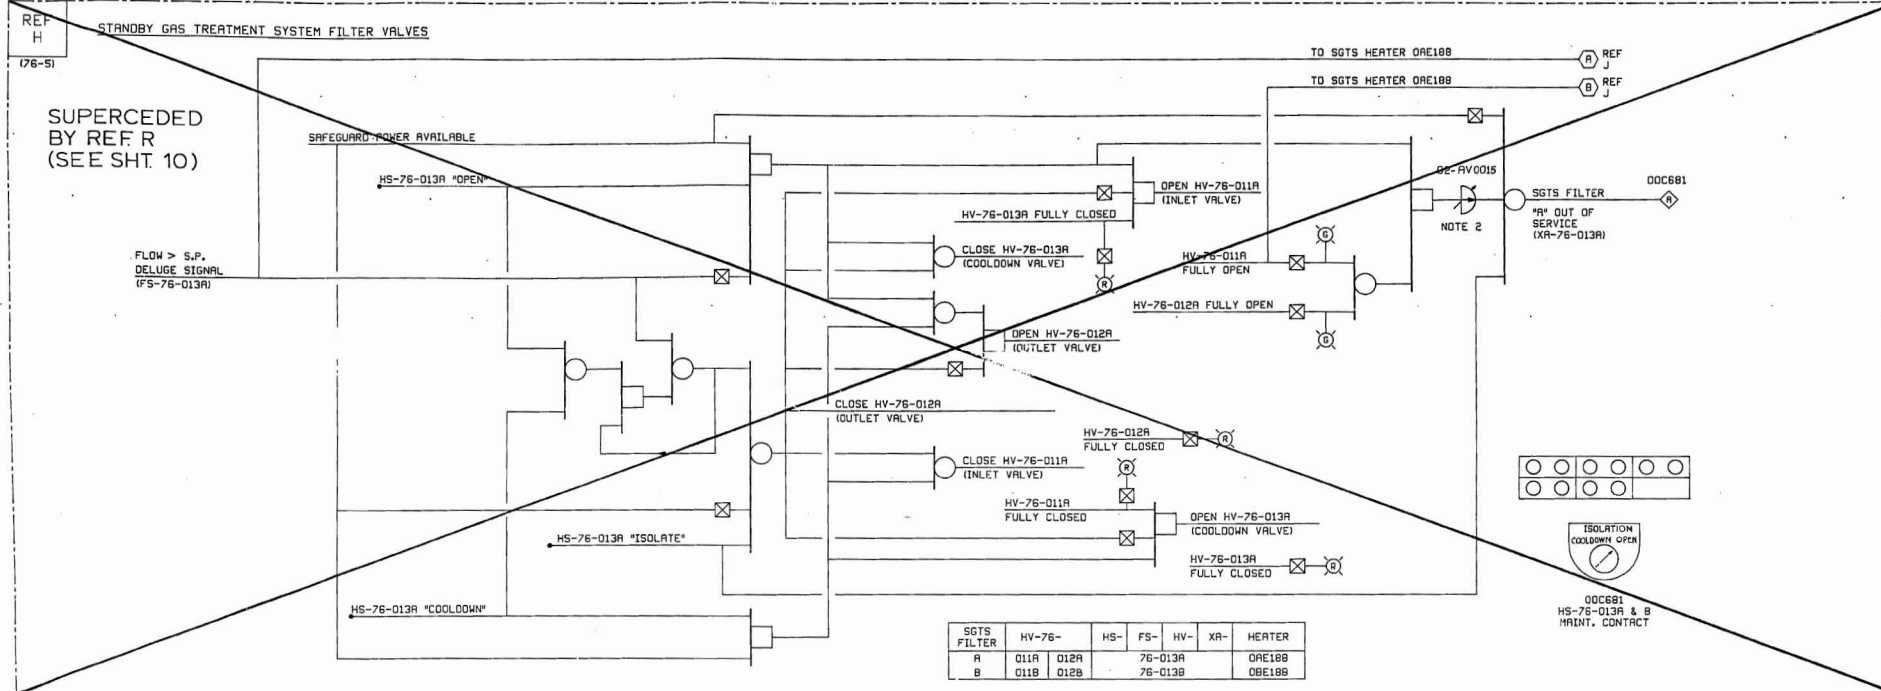

NOTES:

1. THIS FUNCTIONAL DESCRIPTION DRAWING IS BASED ON P & ID M-76, SHT 6, REN 20

ROUTE 1191

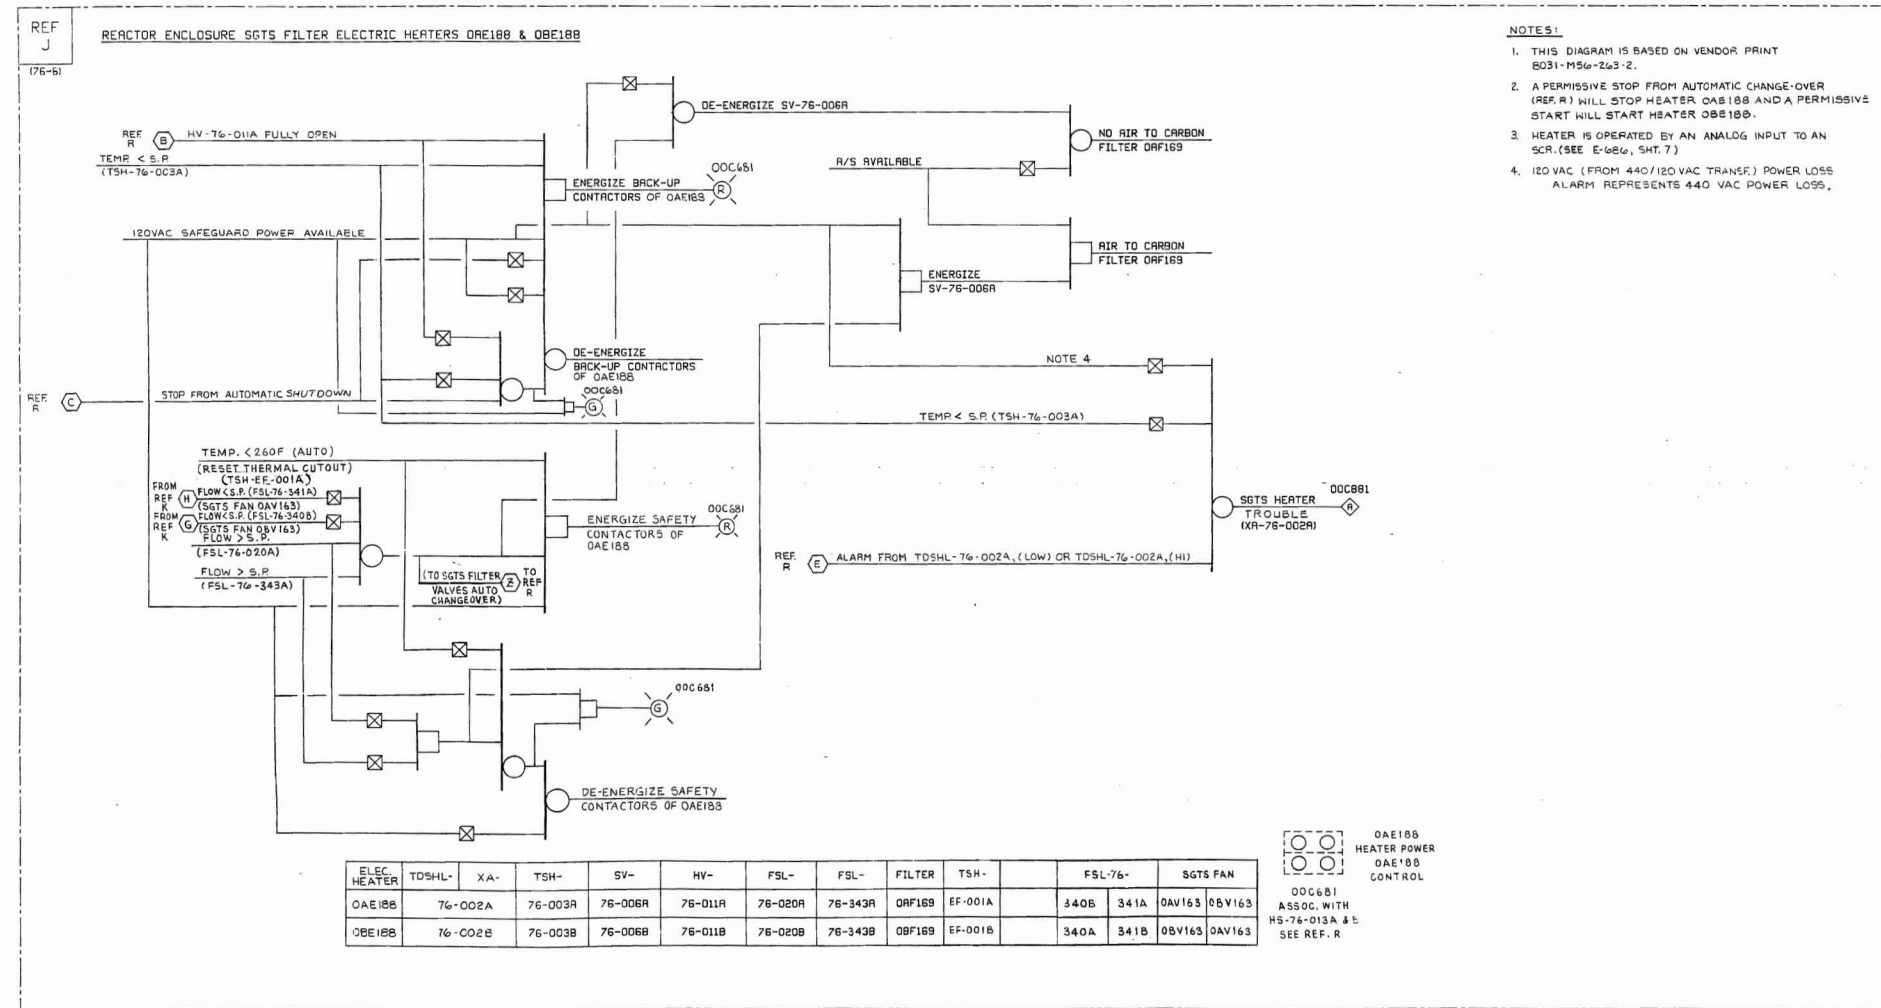

REFERENCE SCHEMATIC DRAWINGS		
REF NO	DWG NO.	TITLE
J	E-454	REACTOR ENCLOSURE SGTS FILTER ELECTRIC HEATERS - COMMON

10	12	92	MOD 6167 INCORPORATED: 10CN "A"	BY	DATE	REVISION	BY	DATE	REVISION	BY	DATE	REVISION
BECHTEL SAN FRANCISCO JIMMERICK GENERATING STATION UNITS 1 & 2 PHILADELPHIA ELECTRIC COMPANY FUNCTIONAL DESCRIPTION REACTOR ENCLOSURE - HVAC 8031 M-76FD SHT 5 10 REF. H, J												