


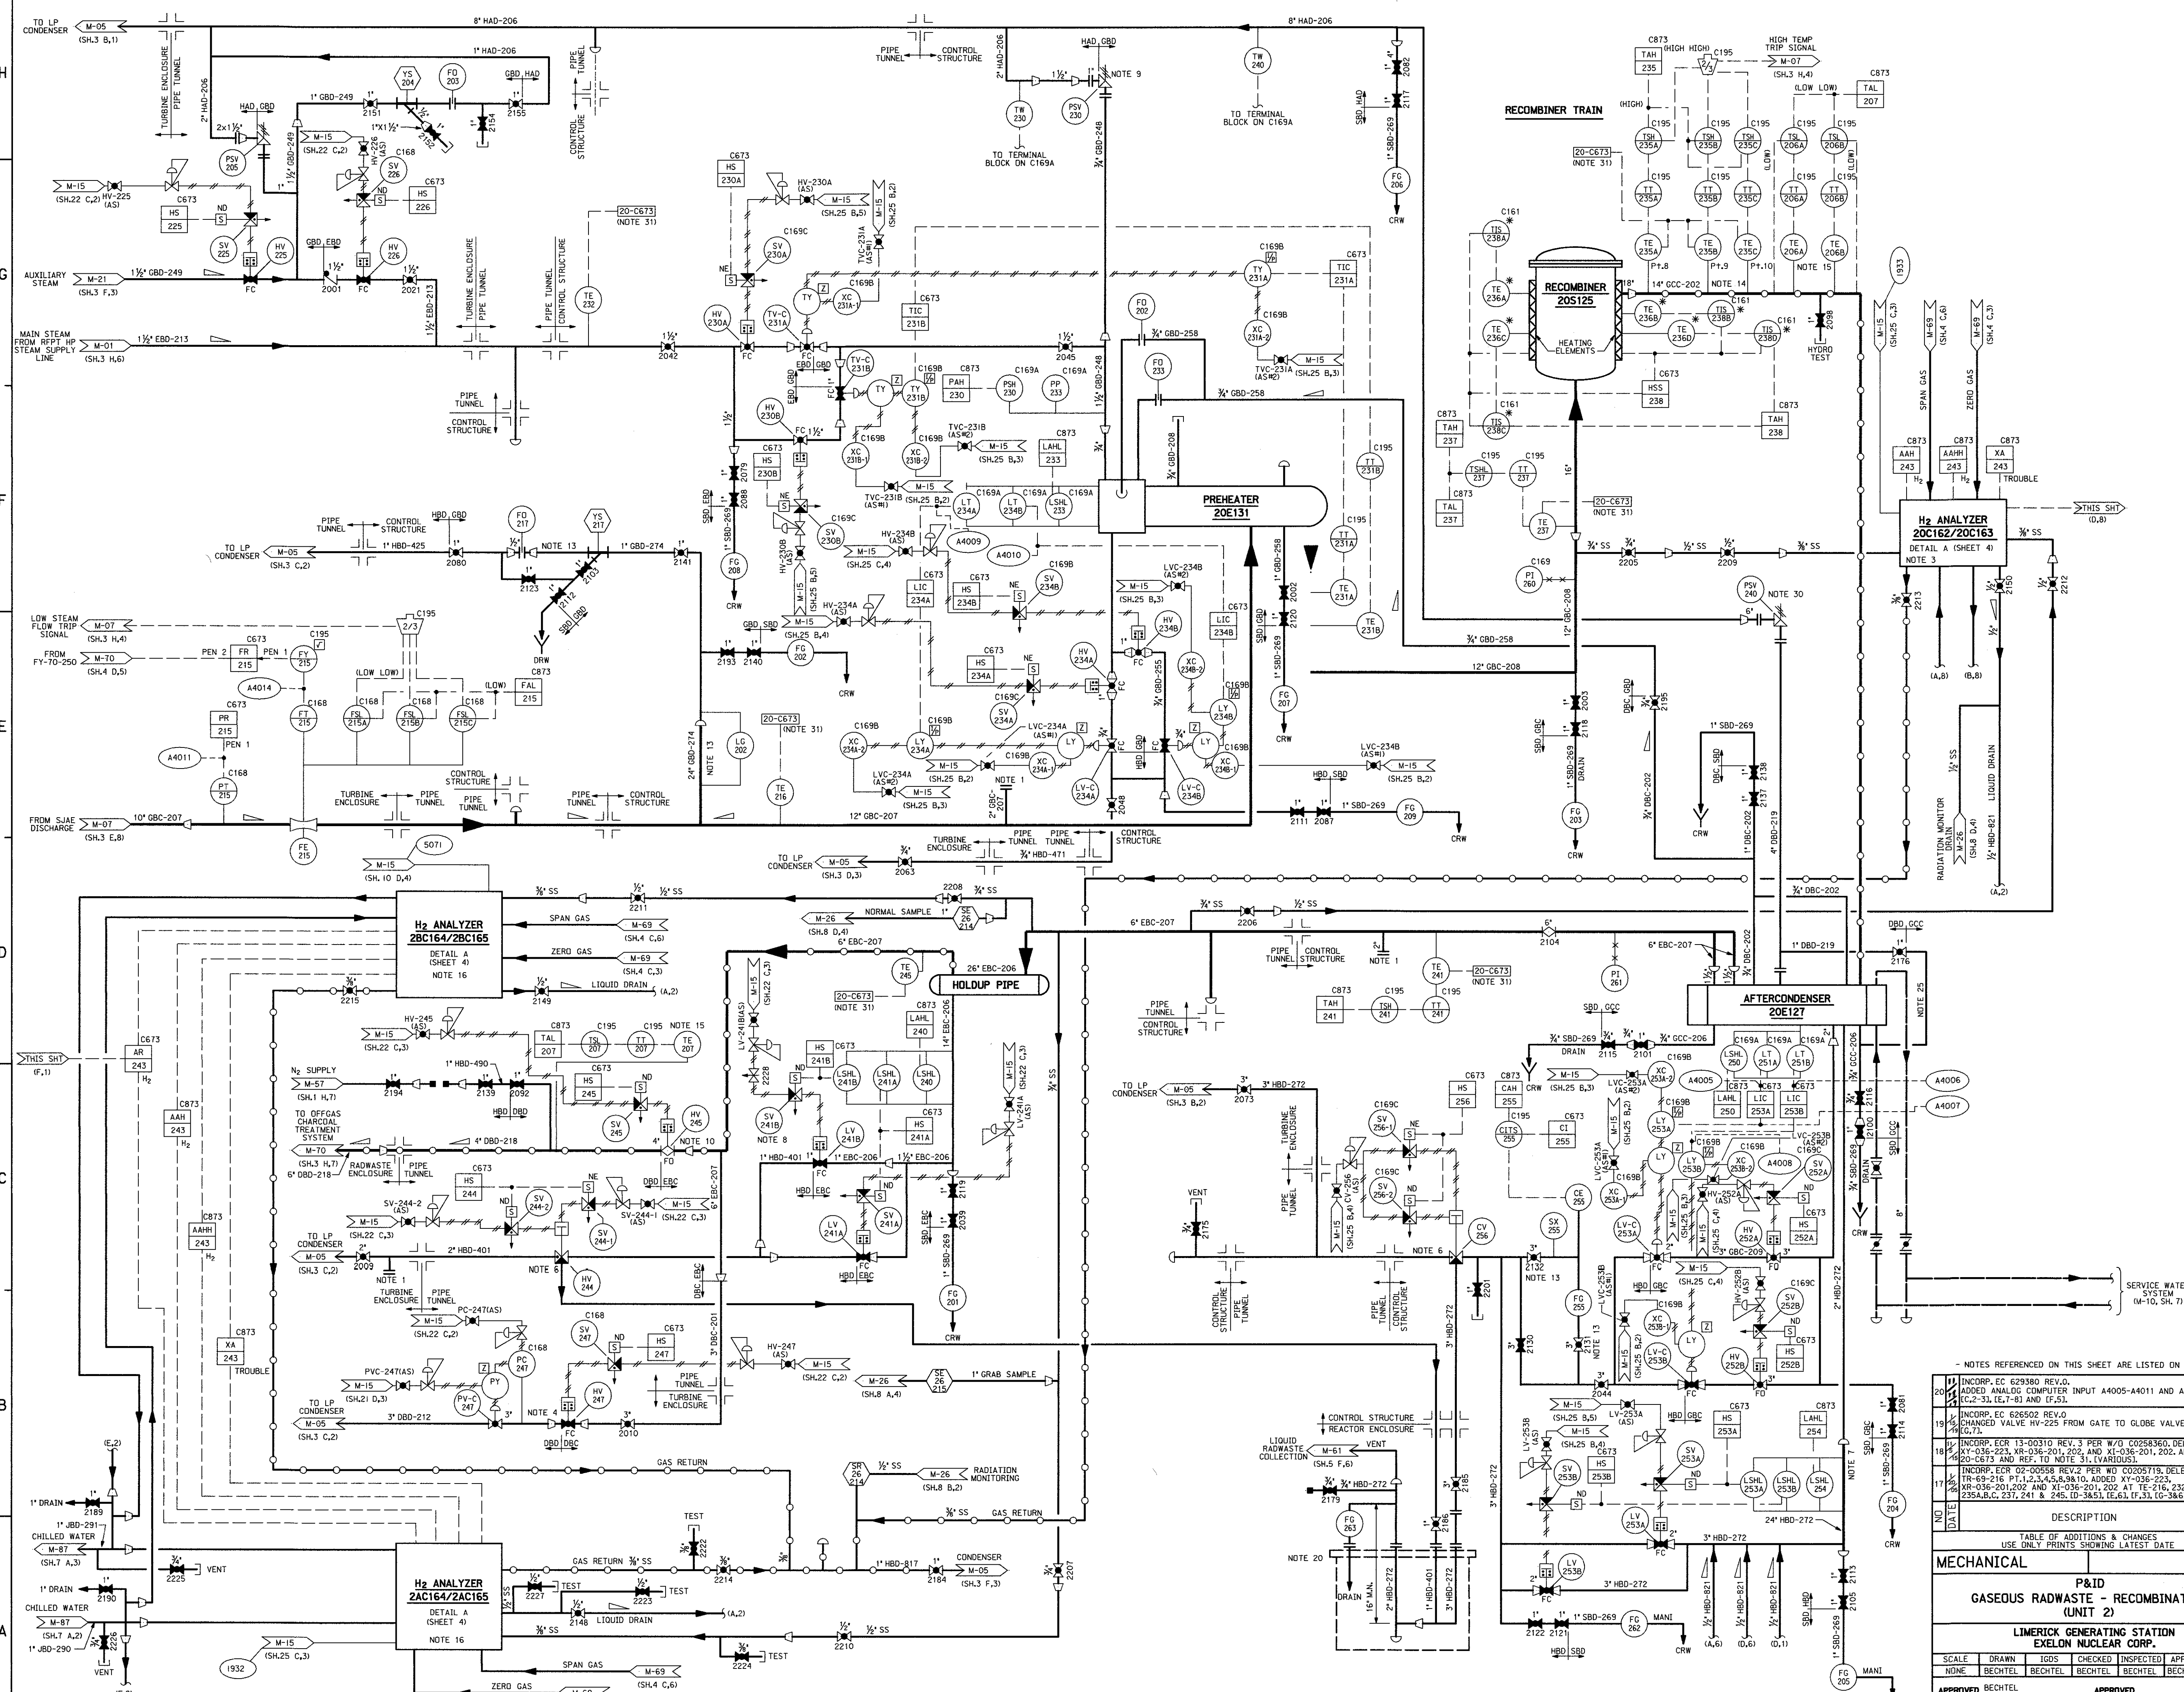

NOTES REFERENCED ON THIS SHEET ARE LISTED ON SHEET 4 -

- INCORP. EOR 629380 REV. Q, ADDED ANALOG COMPUTER INPUT A4005-A4011 AND A4014 (E.C.2-31, E.7-83 AND F.51).
- INCORP. EOR 626502 REV. Q, CHANGED VALVE HV-225 FROM GATE TO GLOBE VALVE. (E.C.1).
- INCORP. EOR 13-00310 REV. 3 PER W/O C0258360, DELETED (E.C.1).
- INCORP. EOR 02-00558 REV.2 PER W/O C0205719, DELETED (E.C.1).
- INCORP. EOR 02-00558 REV.2 PER W/O C0205719, DELETED (E.C.1).

DATE	DESCRIPTION	REV'D	CHK'D	APP'D
12/15/89	TABLE OF ADDITIONS & CHANGES USE ONLY PRINTS SHOWING LATEST DATE			

MECHANICAL		P&ID	
GASEOUS RADWASTE - RECOMBINATION (UNIT 2)			
LIMERICK GENERATING STATION EXELON NUCLEAR CORP.			
SCALE	DRAWN	IGDS	CHECKED
1"=10'	BECHTEL	BECHTEL	BECHTEL
APPROVED	BECHTEL	APPROVED	BECHTEL

SHEET 3 OF 20 CATEGORY A1