


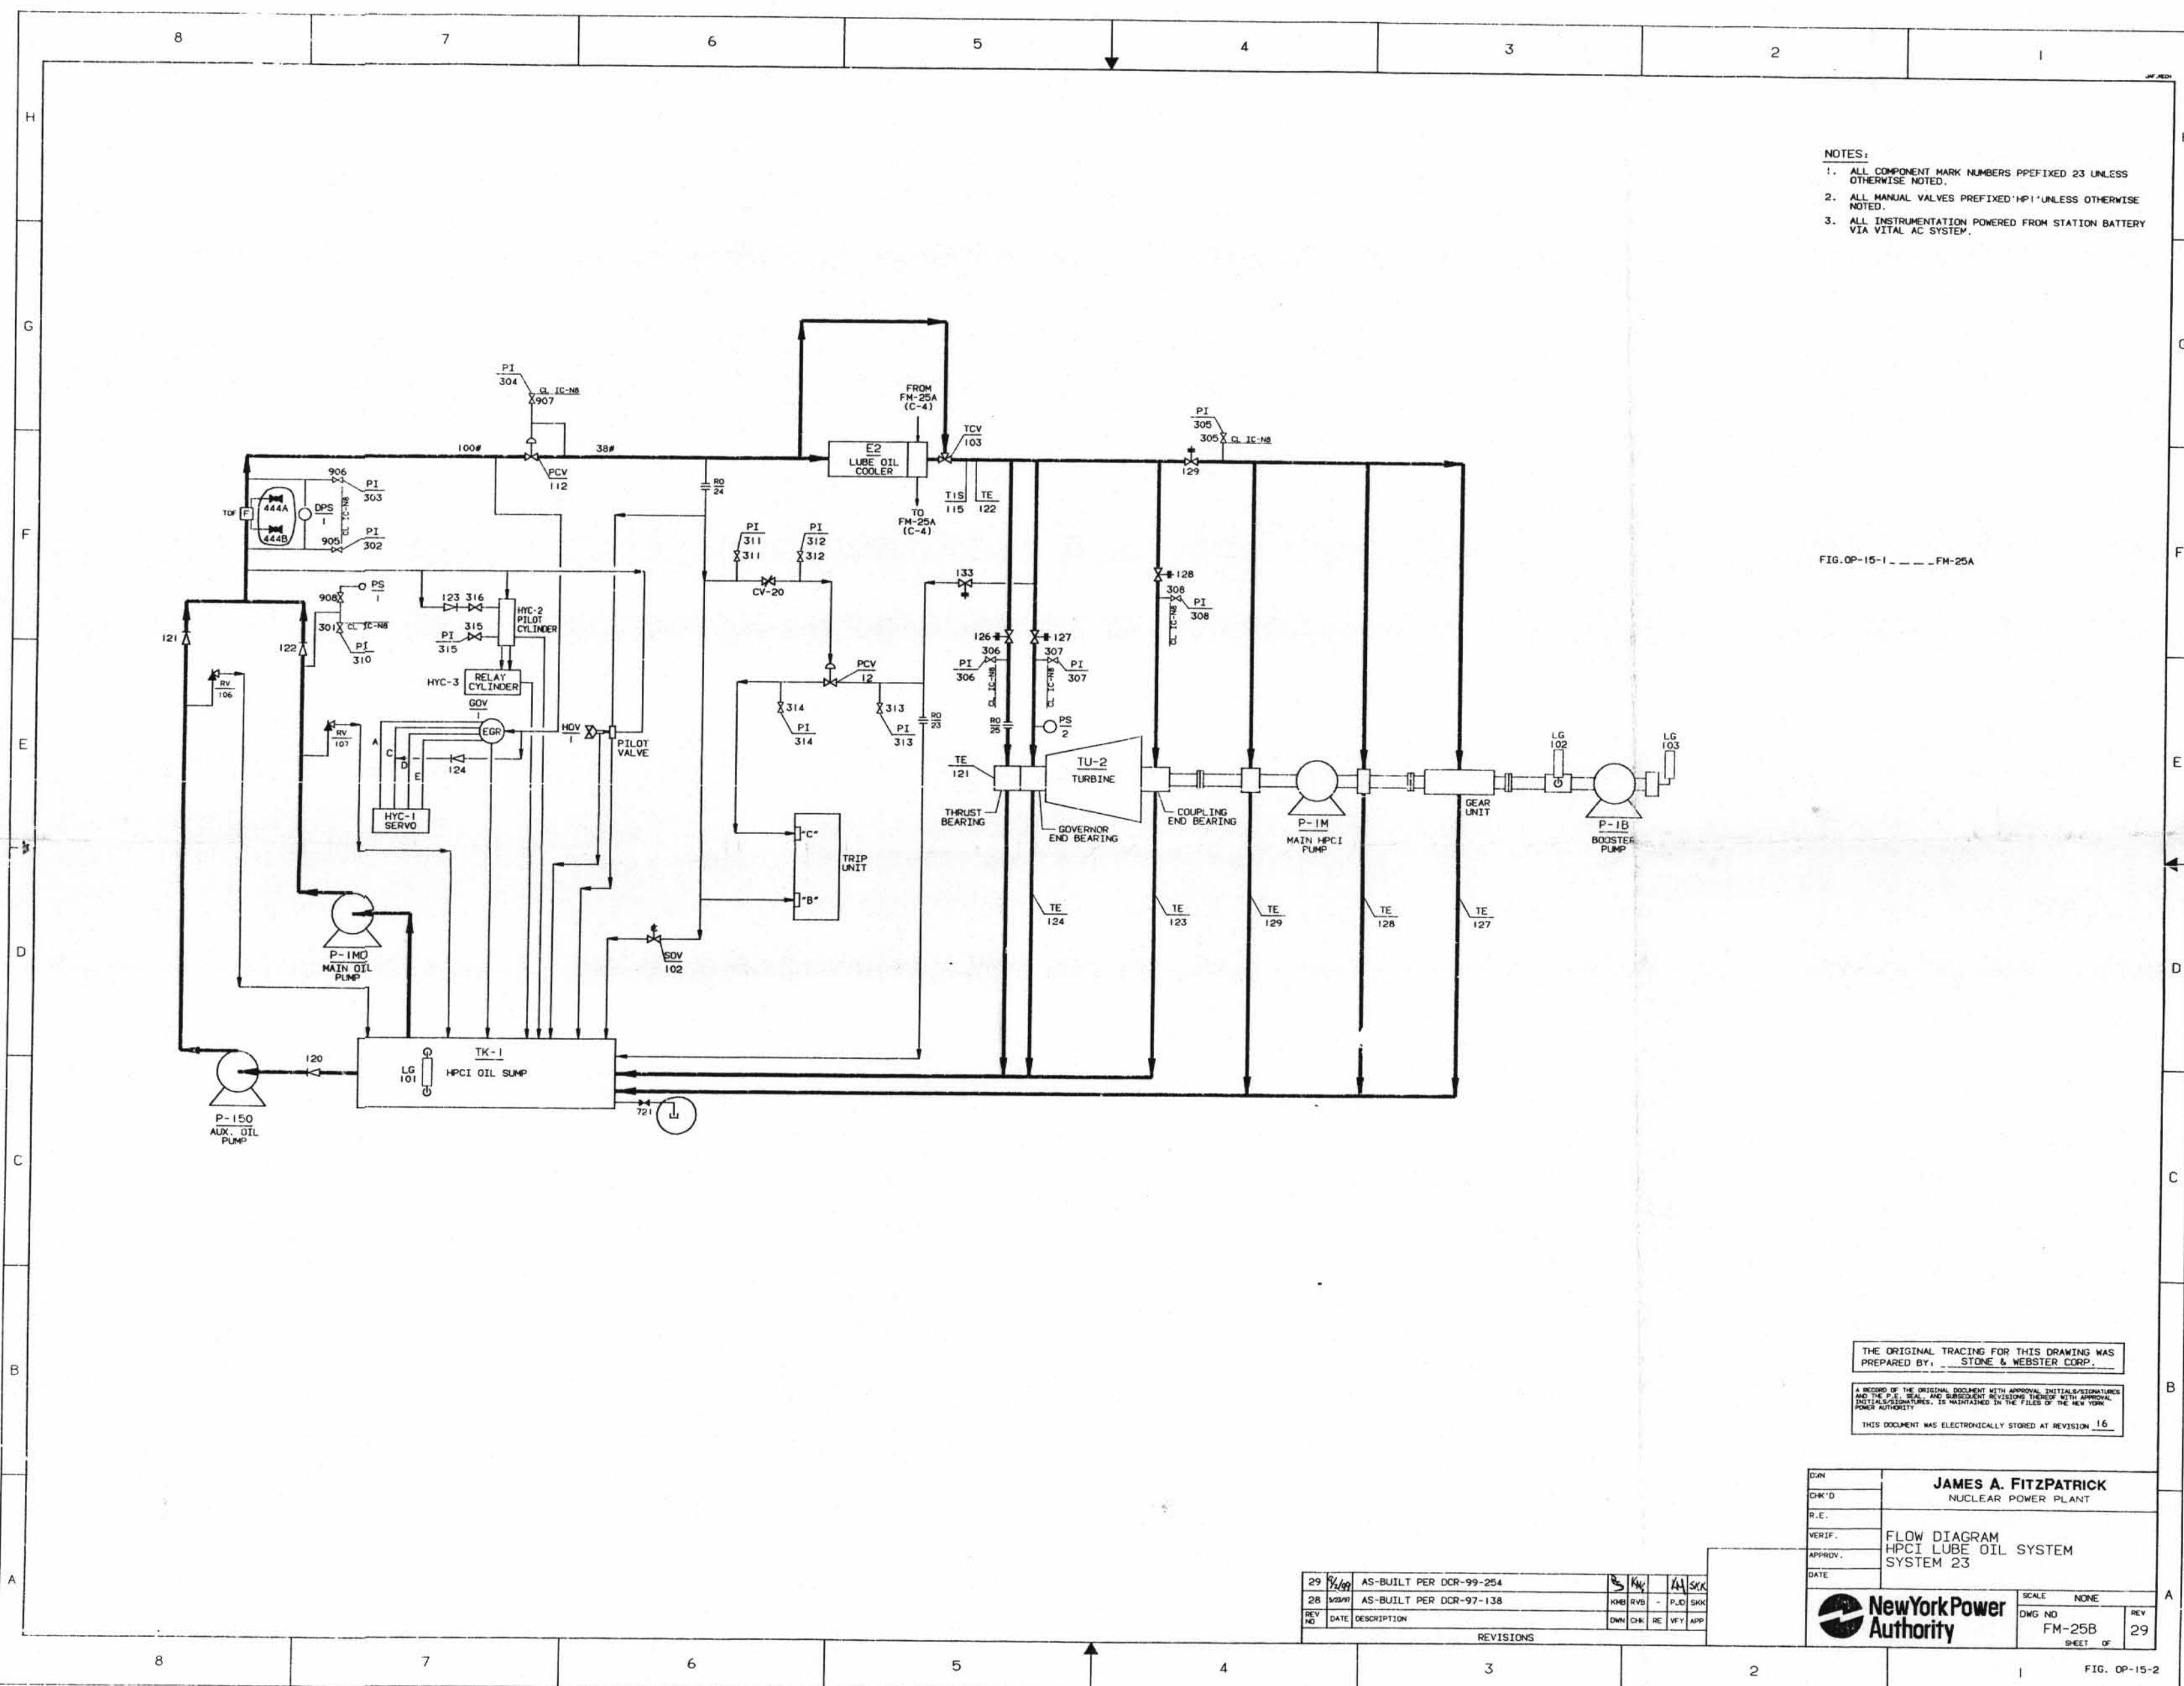

- NOTES:
1. ALL COMPONENT MARK NUMBERS PREFIXED 23 UNLESS OTHERWISE NOTED.
 2. ALL MANUAL VALVES PREFIXED HP1 UNLESS OTHERWISE NOTED.
 3. ALL INSTRUMENTATION POWERED FROM STATION BATTERY VIA VITAL AC SYSTEM.

FIG. OP-15-1 - FM-25A

THE ORIGINAL TRACING FOR THIS DRAWING WAS PREPARED BY: STONE & WEBSTER CORP.

A RECORD OF THE ORIGINAL DOCUMENT WITH APPROVAL, INITIALS/SIGNATURES AND DATE OF REVIEW, AND REVISIONS, IS MAINTAINED IN THE FILES OF THE NEW YORK POWER AUTHORITY.

THIS DOCUMENT WAS ELECTRONICALLY STORED AT REVISION 16.

JAMES A. FITZPATRICK NUCLEAR POWER PLANT	
FLOW DIAGRAM HPCI LUBE OIL SYSTEM SYSTEM 23	
New York Power Authority	
SCALE: NONE	REV: 29
DWG NO: FM-25B	SHEET OF

REV	DATE	DESCRIPTION	BY	CHK	APP
29	9/1/09	AS-BUILT PER DCR-99-254	SK	AK	SK
28	5/28/09	AS-BUILT PER DCR-97-138	KOB	RVS	PLD

REVISIONS

UNCONTROLLED
DRAWING

Copy Date JUN 01 2009

CAUTION - Extended use of drawing copy may result in inaccuracy due to subsequent changes and drawing updates.

D-4