


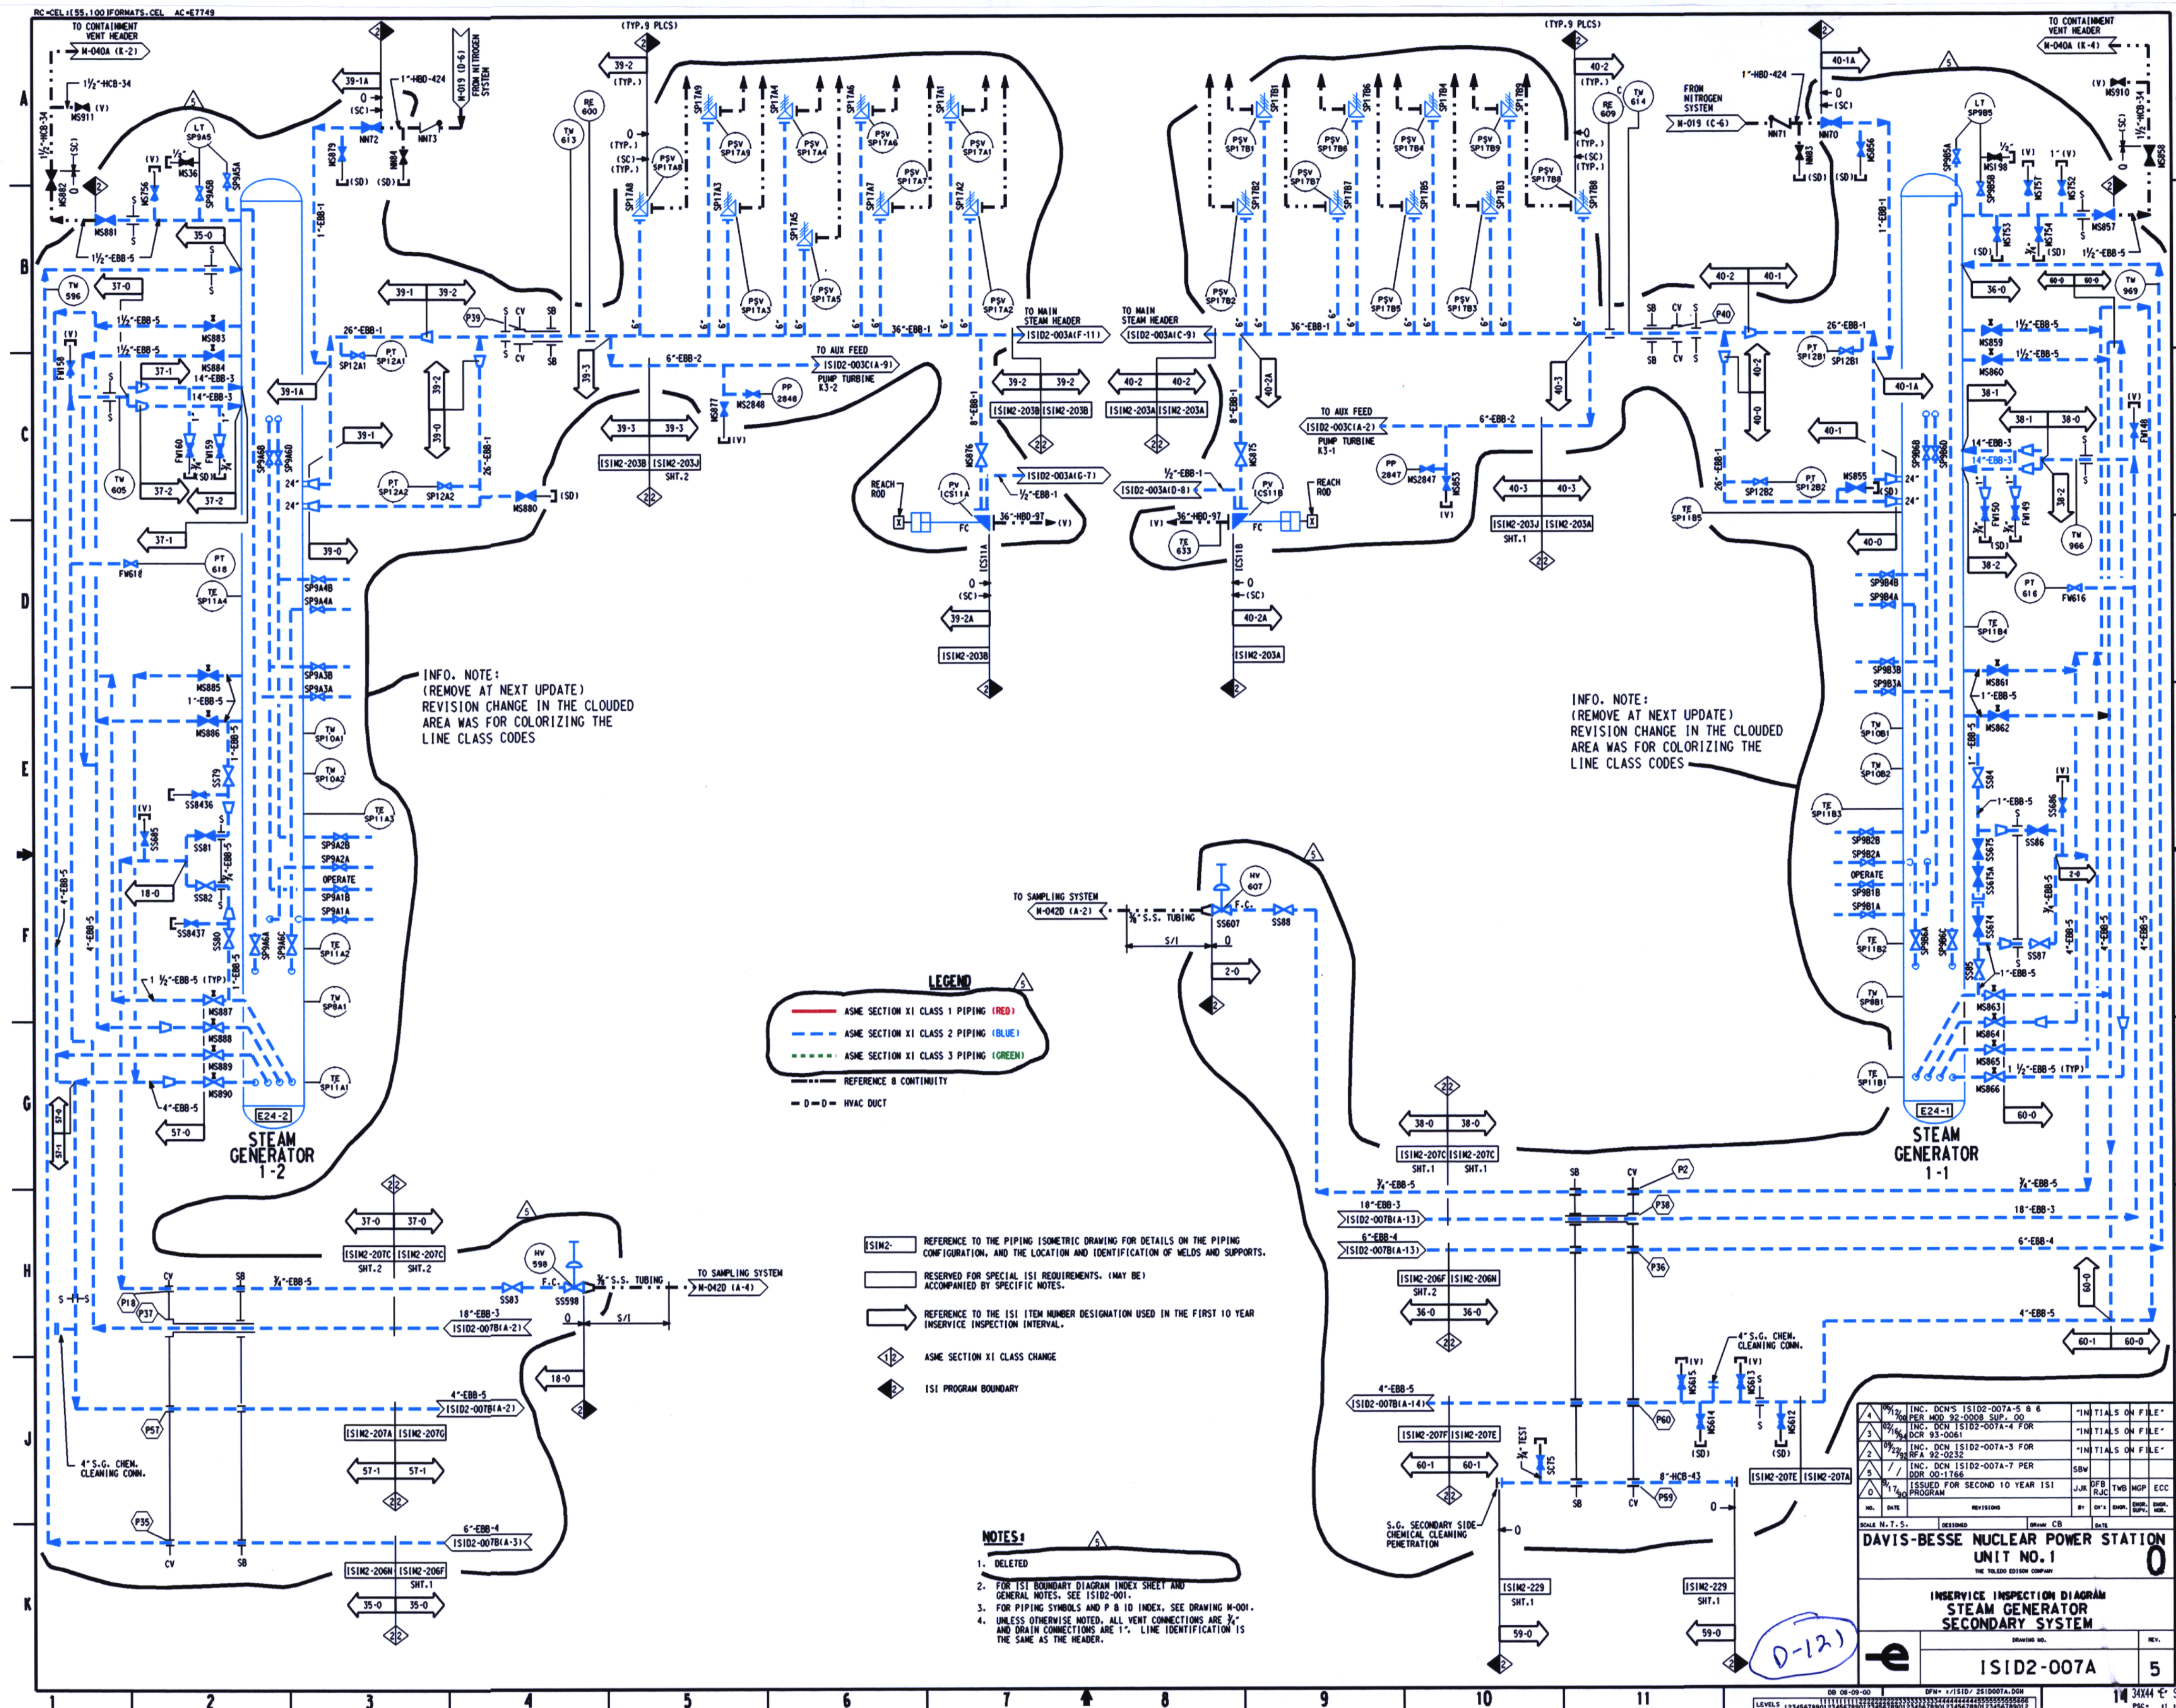

INFO. NOTE:
(REMOVE AT NEXT UPDATE)
REVISION CHANGE IN THE CLOUDED
AREA WAS FOR COLORIZING THE
LINE CLASS CODES

INFO. NOTE:
(REMOVE AT NEXT UPDATE)
REVISION CHANGE IN THE CLOUDED
AREA WAS FOR COLORIZING THE
LINE CLASS CODES

LEGEND

- ASME SECTION XI CLASS 1 PIPING (RED)
- ASME SECTION XI CLASS 2 PIPING (BLUE)
- ASME SECTION XI CLASS 3 PIPING (GREEN)
- REFERENCE & CONTINUITY
- D = D = HVAC DUCT

- IS1M2- REFERENCE TO THE PIPING ISOMETRIC DRAWING FOR DETAILS ON THE PIPING CONFIGURATION, AND THE LOCATION AND IDENTIFICATION OF WELDS AND SUPPORTS.
- RESERVED FOR SPECIAL ISI REQUIREMENTS. (MAY BE ACCOMPANIED BY SPECIFIC NOTES.)
- REFERENCE TO THE ISI ITEM NUMBER DESIGNATION USED IN THE FIRST 10 YEAR INSERVICE INSPECTION INTERVAL.
- ASME SECTION XI CLASS CHANGE
- ISI PROGRAM BOUNDARY

NOTES

- DELETED
- FOR ISI BOUNDARY DIAGRAM INDEX SHEET AND GENERAL NOTES. SEE IS1D2-001.
- FOR PIPING SYMBOLS AND P & ID INDEX. SEE DRAWING M-001.
- UNLESS OTHERWISE NOTED, ALL VENT CONNECTIONS ARE 1/2" LINE IDENTIFICATION IS THE SAME AS THE HEADER.

NO.	DATE	REVISIONS	BY	CHK'D	ENGR.	DRW.	APP.
1	08-09-00	DESIGNED	CB				
2		ISSUED FOR SECOND TO YEAR ISI PROGRAM	JJK	DFB	RJC	MCP	ECC
3							
4							
5							

DAVIS-BESSE NUCLEAR POWER STATION UNIT NO. 1		0
INSERVICE INSPECTION DIAGRAM STEAM GENERATOR SECONDARY SYSTEM		
DRAWING NO.		REV.
IS1D2-007A		5