


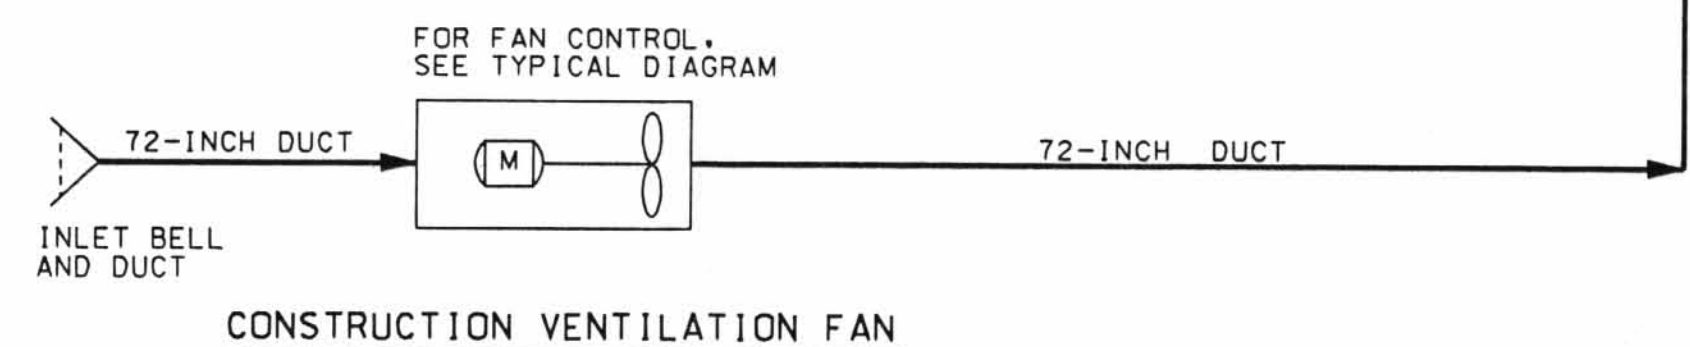

1. CONSTRUCTION FANS FOR DEVELOPMENT SIDE VENTILATION SHALL BE SINKING AREA CONTROLLED LOCALLY AND ARE NOT SHOWN ON THIS SCHEMATIC.
2. BOOSTER FAN NUMBERS VARY WITH LOCATION OF THE WORK.
3. BOOSTER FAN SEQUENTIAL STARTING INTERLOCKS NOT SHOWN.
4. FOR GENERAL ARRANGEMENT OF VENTILATION PLAN SEE DRAWING 86030.
5. FOR SYMBOL DESCRIPTIONS AND INSTRUMENT IDENTIFICATION, SEE DRAWING 86035.

[illegible]

APERTURE
CARD

981204014

THIS DRAWING IS PRELIMINARY AND NOT
INTENDED FOR CONSTRUCTION. PROCUREMENT
OR FABRICATION.

DESIGN INPUTS
SEE DRAWING INPUTS LIST

[illegible]

REPOSITORY DESIGN
SS VENT - DUCTED EXHAUS
MONITORING, P&ID
CONDITION 1, SHEET 1 OF 1

SIZE	DOCUMENT	CI IDENTIFIER	DRAWING NO.
D	IDENTIFIER: BCAJ00000		01717-2700-86036
SCALE	QA CLASSIFICATION	V.B.S.	CAD FILE
NONE	N/A	1.2.4	CSYS:86036

СЗР 040211

RECORD DESIG

1-JUL-1998 17:11