


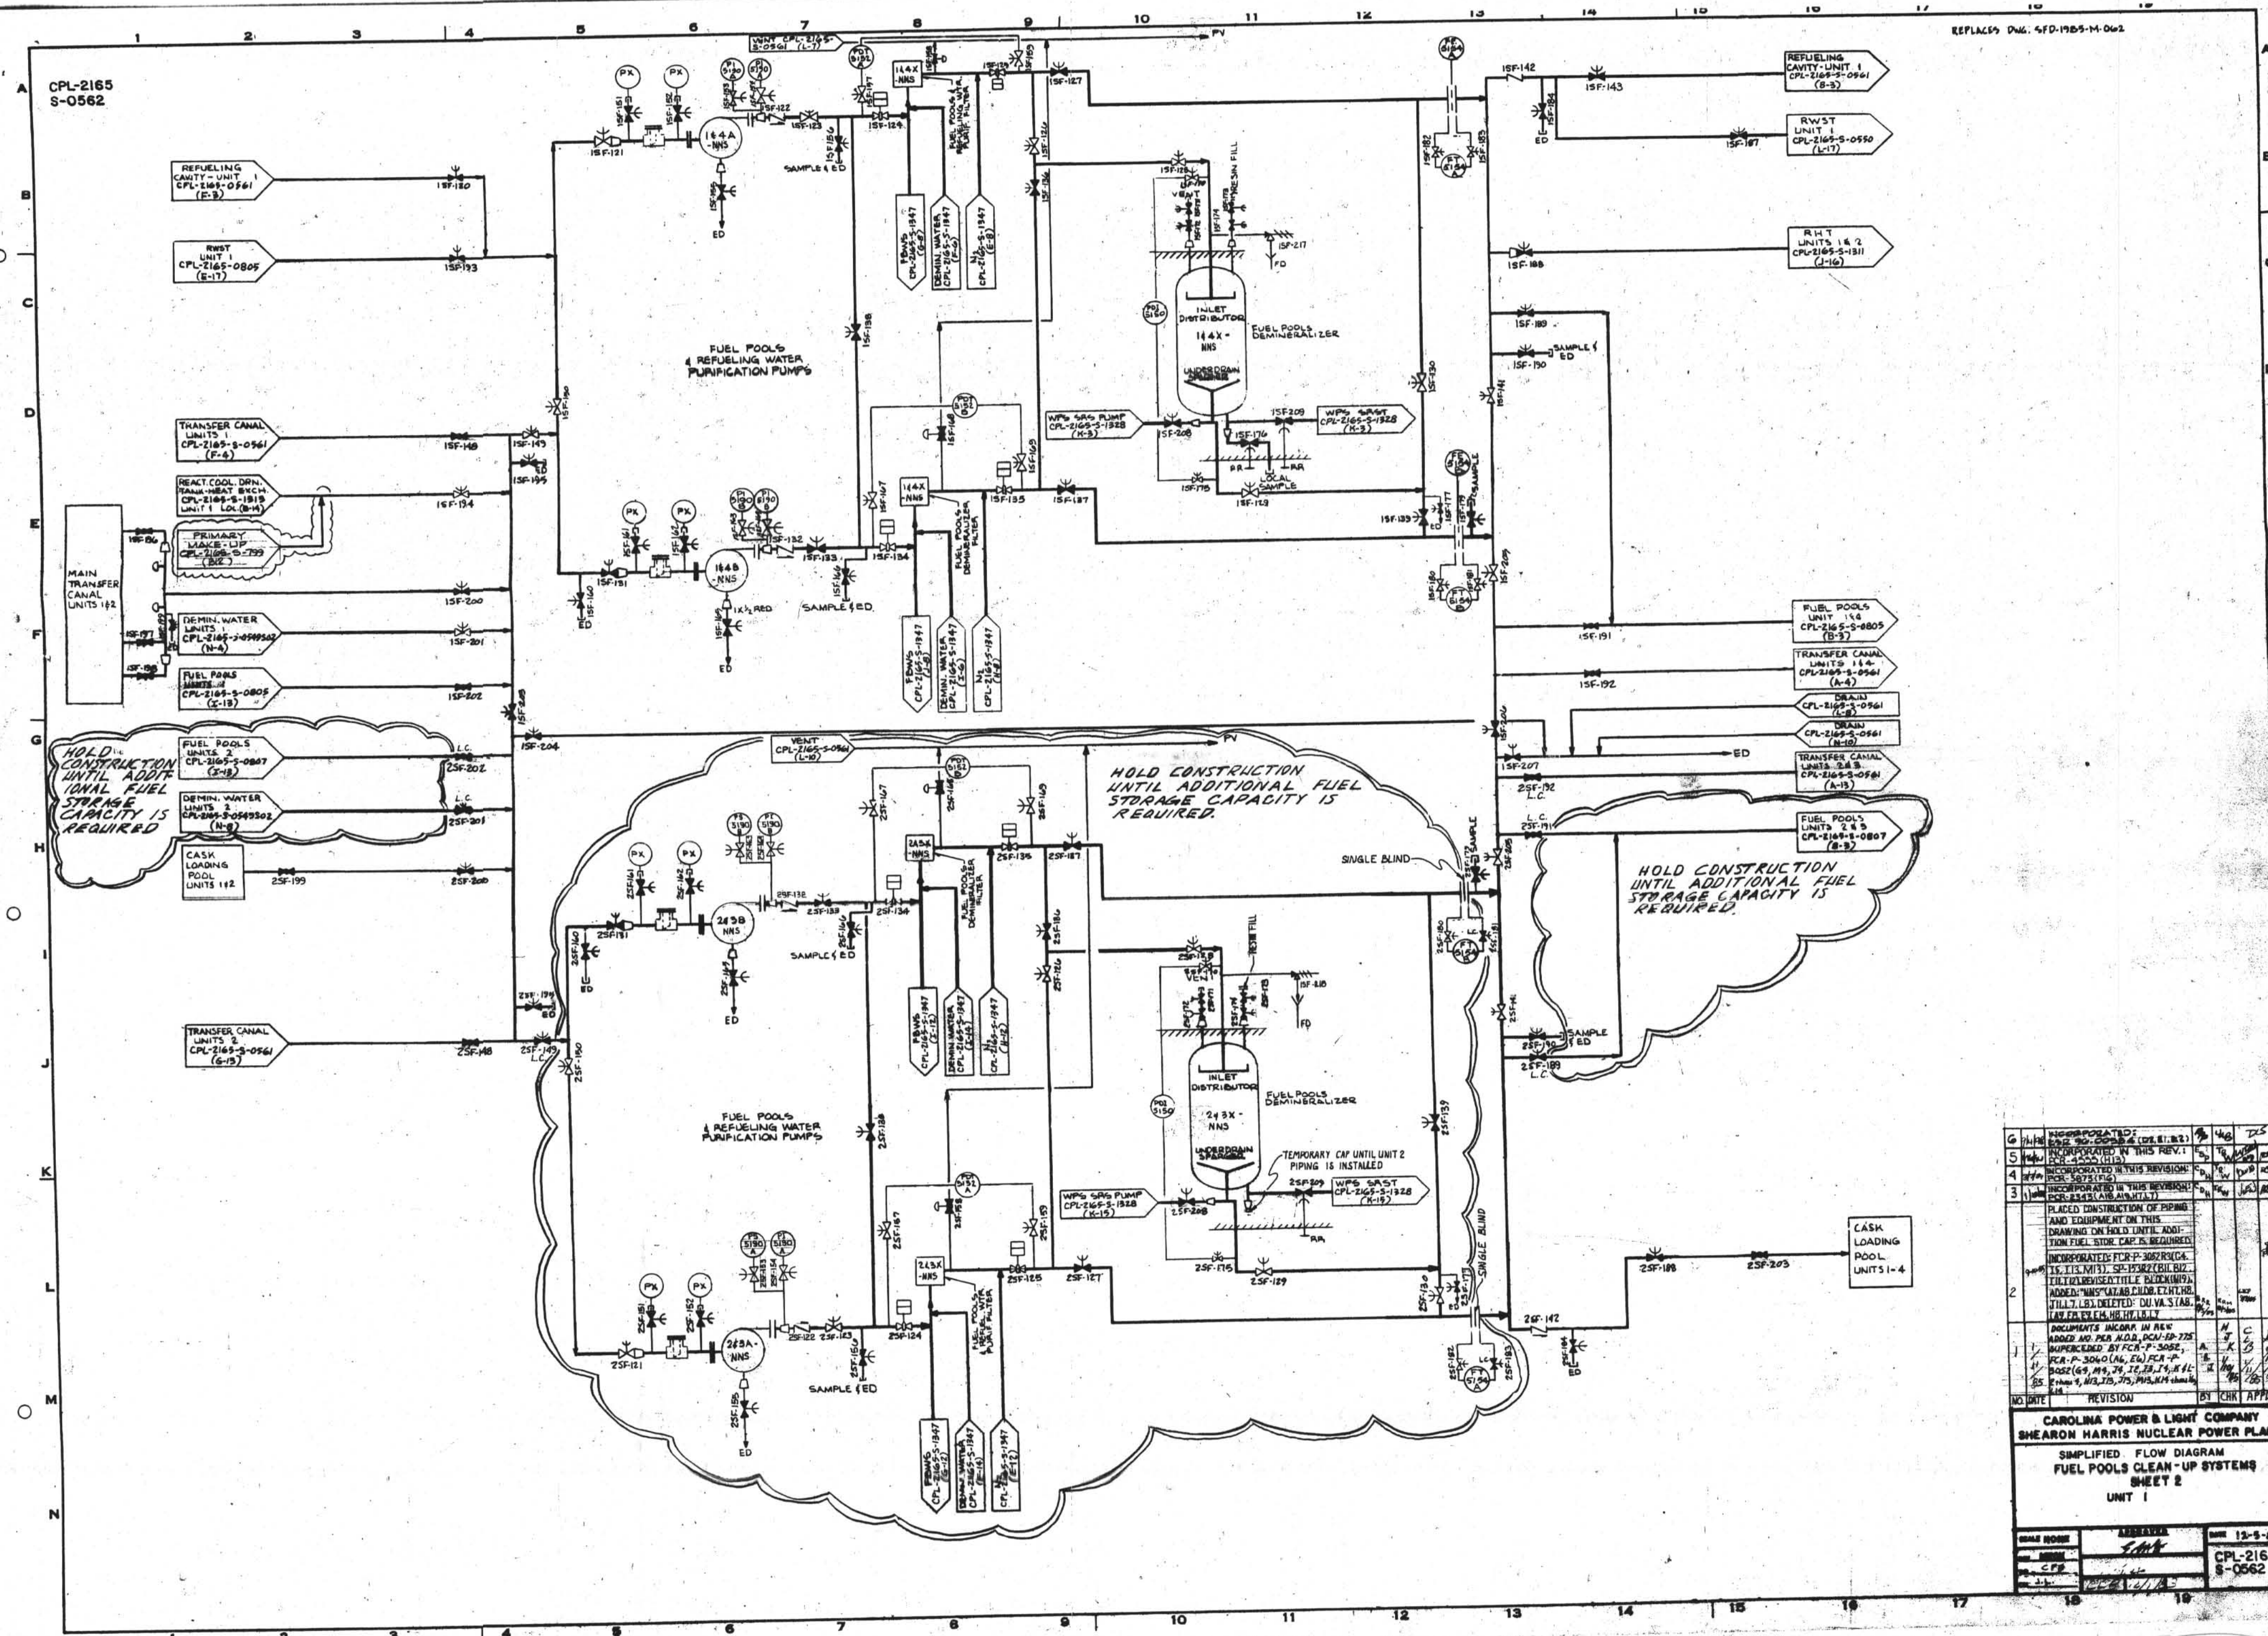

6	1/16	INCORPORATED: 1/25/78 REV. 252-0000 (LDR, E, R, Z)	1/16	4/6	2/5
5	1/16	INCORPORATED IN THIS REV. 1: FCR-4000 (H13)	1/16	4/6	2/5
4	1/16	INCORPORATED IN THIS REVISION: REV. 5073 (H13)	1/16	4/6	2/5
3	1/16	INCORPORATED IN THIS REVISION: REV. 2423 (AMB, ANV, J17)	1/16	4/6	2/5
PLACED CONSTRUCTION OF PIPING AND EQUIPMENT ON THE DRAWING ON HOLD UNTIL ADDI- TION FUEL STOR. CAP. IS REQUIRED					
INCORPORATED: FCR-P-3002 (CA, TS, T13, M11). SP: 159272 (BU, R12, T12) TO REVERSE SET PLUCKING (H13). ADDN: "N13 CA18 CHND E7, H1, H2, J11, L7, L8) DELETED: DU VA'S (A8, L6, F1, F2, F4, H6, H7, L1, L7)					
2	1/16	DOCUMENTS INCORP IN REV. ADDED AND PER N13, FCN-HP-775 SUPERSEDED BY FCN-P-3002, FCR-P-3001 (L6, L6), FCN-P- 3002 (G, H9, J4, J6, J8, J9, J1, H1, H2, H3, H4, H5, J75, J143, N13, N14, N15, N16, N17)	1/16	4/6	2/5
1	1/16	NO DATE	1/16	4/6	2/5
REVISION			BY CHK APPR		
CAROLINA POWER & LIGHT COMPANY SHEARON HARRIS NUCLEAR POWER PLANT					
SIMPLIFIED FLOW DIAGRAM FUEL POOLS CLEAN-UP SYSTEMS SHEET 2 UNIT 1					
DRAWN BY			DATE 12-5-78		
CHECKED			CPL-216		
DATE			S-0562		

D-LA